

THIS DOCUMENT IS THE PROPERTY OF
LOOK ARCHITECTURE AND THE
IDEAS OR DRAWINGS PRESENTED HERE
SHALL NOT BE USED WITHOUT THE
SPECIFIC WRITTEN CONSENT OF
LOOK ARCHITECTURE

EMERSON RESIDENCE ADDITION/REMODEL
21677 MOUNTSFIELD DRIVE
GOLDEN, CO 80401


Project: ADDITION/REMODEL
Drawn by: RGL
Checked by: RGL
REVISIONS:

REVISIONS:
Draft for Permit : 12-26-18
Submit for Permit: 1-29-18
for Construction Set:

Sheet Contents:
FIRST FLOOR ELECTRICAL PLAN

DRAWINGS ARE NOT TO BE SCALED.
ANY UNCLEAR OR CONFLICTING
DIMENSIONS, DETAILS OR CONDITIONS
ARE TO BE CLARIFIED WITH THE
ARCHITECT / DESIGNER PRIOR TO
CONSTRUCTION OR FABRICATION.
Sheet:

EA2.1

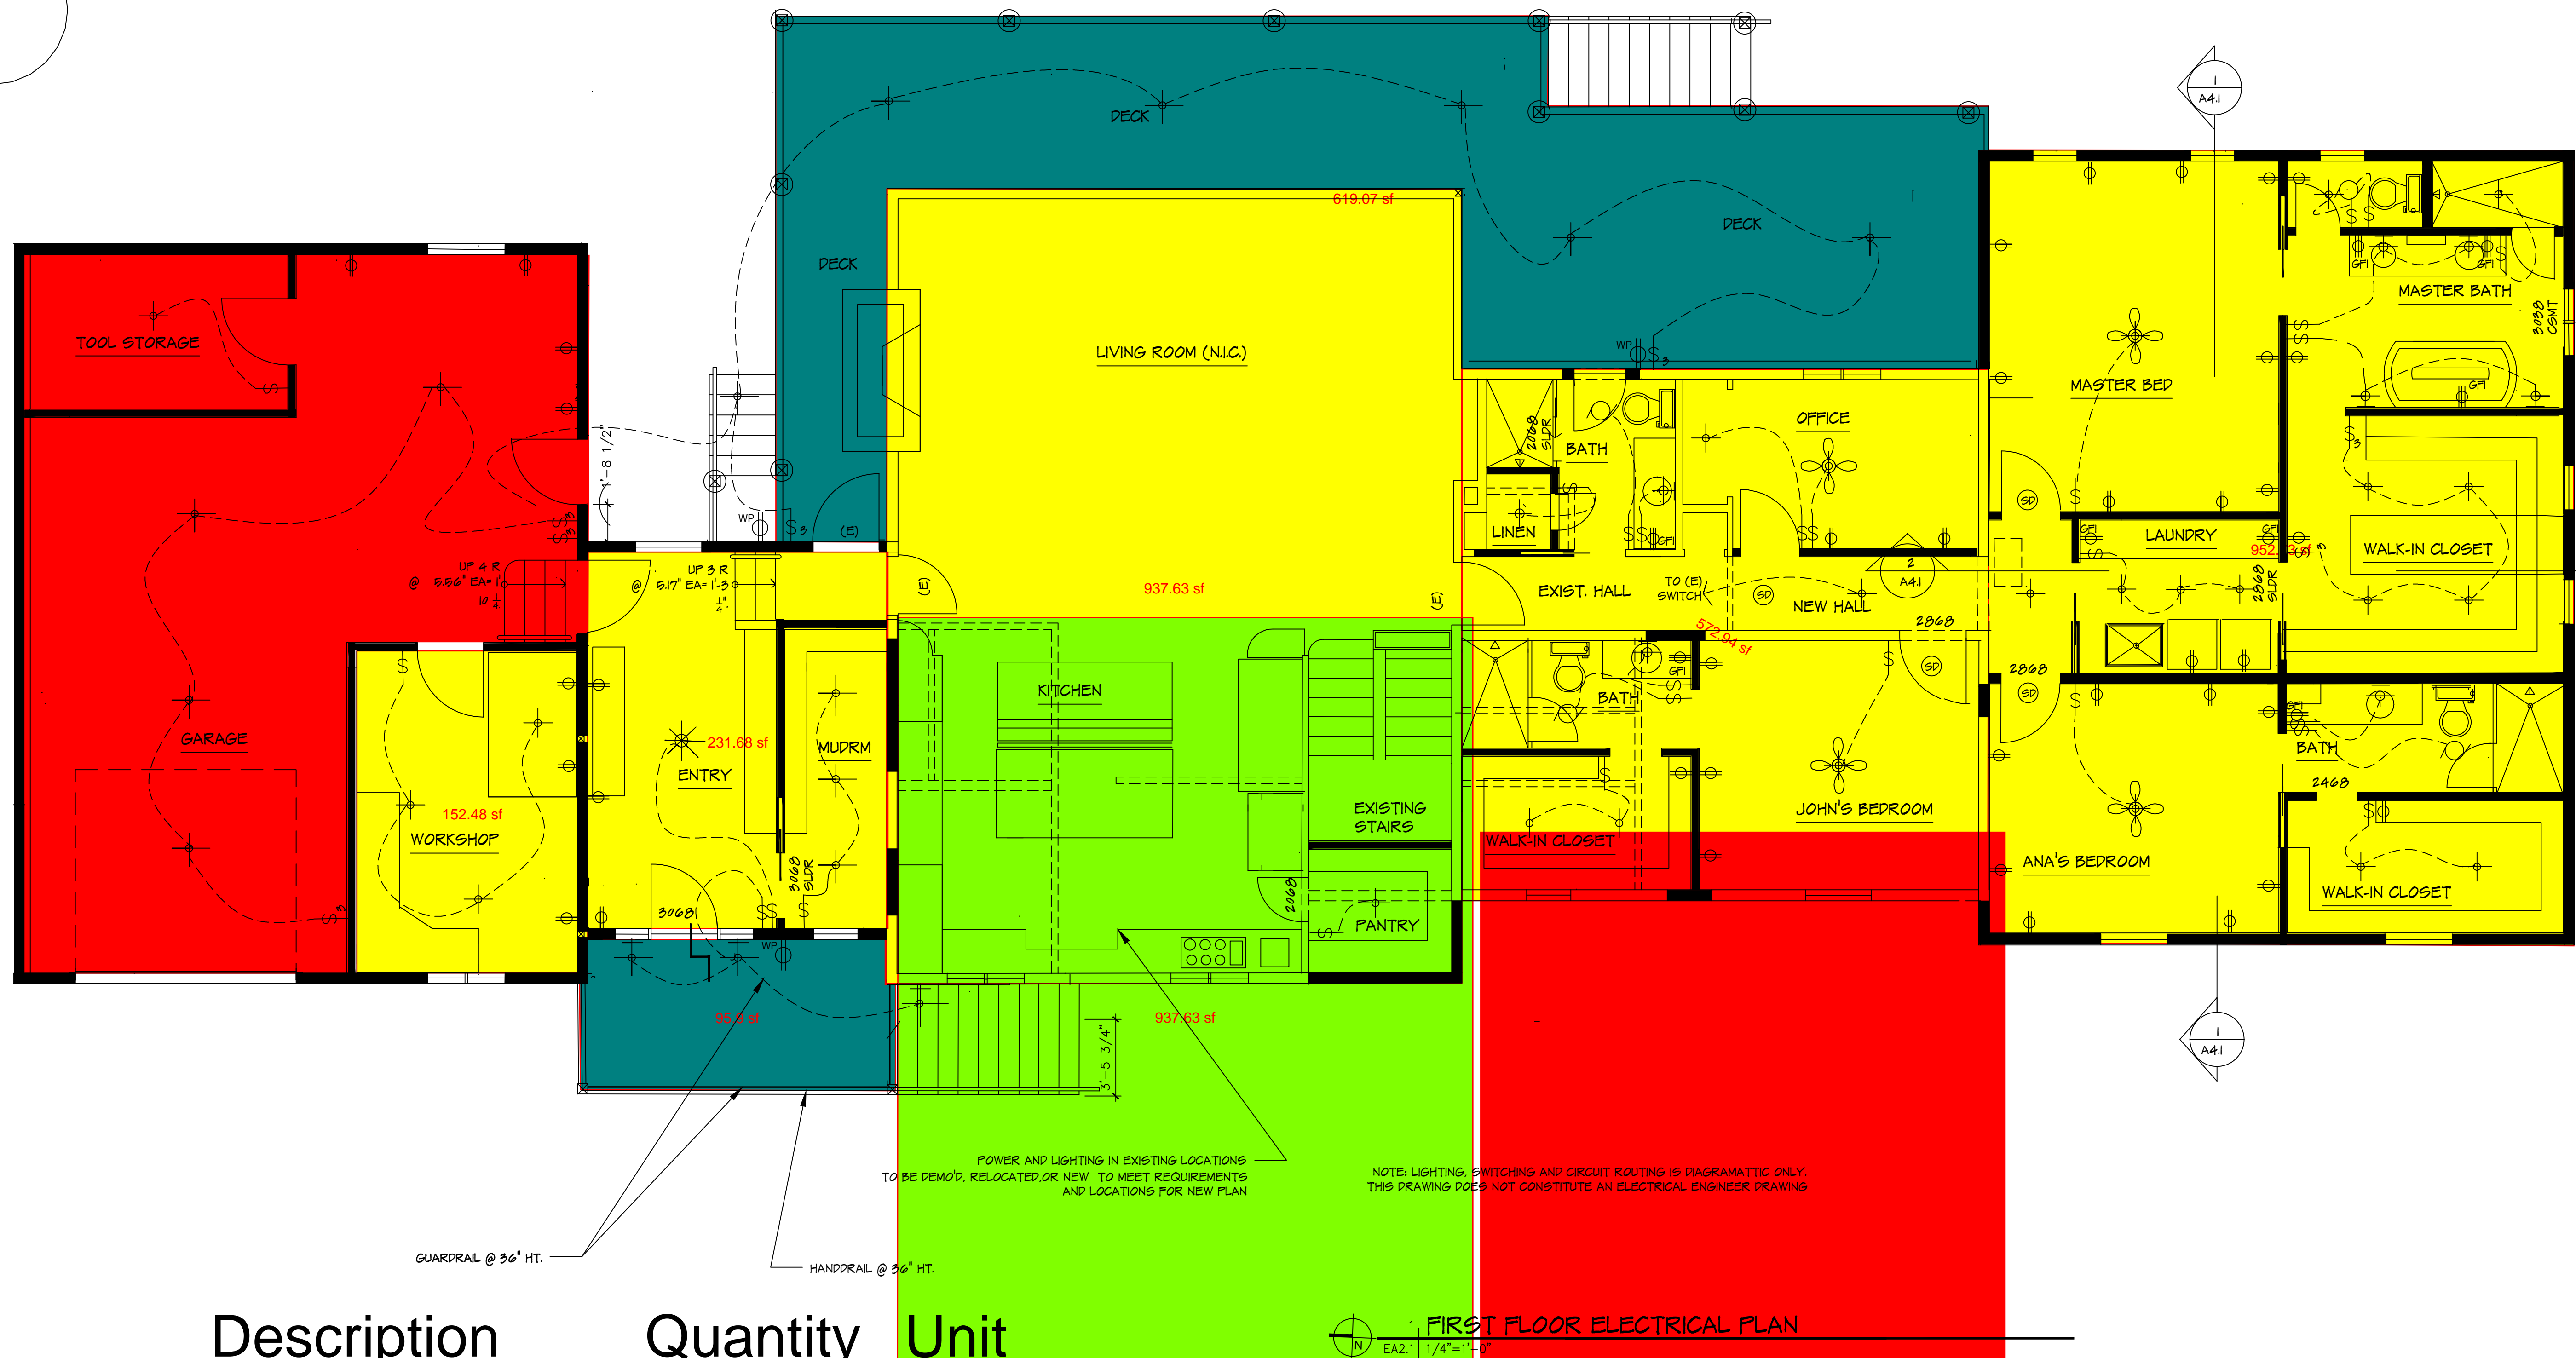

POWER AND LIGHTING IN EXISTING LOCATIONS TO BE DEMO'D, RELOCATED OR NEW TO MEET REQUIREMENTS AND LOCATIONS FOR NEW PLAN
NOTE: LIGHTING, SWITCHING AND CIRCUIT ROUTING IS DIAGRAMMATIC ONLY. THIS DRAWING DOES NOT CONSTITUTE AN ELECTRICAL ENGINEER DRAWING

Description	Quantity	Unit
Area Measurement	2,847.46	sf
Basement	937.63	sf
Deck	619.07	sf
Front Deck	95.90	sf
Garage	1,240.08	sf

5023 Total SF

1 FIRST FLOOR ELECTRICAL PLAN
EA2.1 1/4"=1'-0"

LEGEND

- SWITCH
- 3-WAY WALL SWITCH
- ARC FAULT INTERRUPTER PROTECTED DUPLEX OUTLET
- WATER PROOF OUTDOOR RECEPTACLE
- GROUND FAULT INTERRUPTER PROTECTED
- CO DETECTOR
- SMOKE DETECTOR
- EXHAUST FAN
- CEILING FAN
- 220V AT ELEC DRYER
- RECESSED LIGHT
- CEILING MOUNTED LIGHT FIXTURE
- WALL MOUNTED LIGHT FIXTURE
- CHANDELIER