

 


916 DOVE CREEK CT.
LOT 18 BLOCK A
HATCREEK EST.
BARTONVILLE, TX
DENTON COUNTY

DATE: 2-15-19 PD1
3-22-19 PD2
4-4-19 PD3
4-24-19 S/O
5-6-19 S/O2
5-6-19 S/O2

1. CONTRACTOR TO VERIFY ALL DIMENSIONS PRIOR TO BEGINNING CONSTRUCTION. NOTIFY ARCHITECT OF ANY DISCREPANCIES IMMEDIATELY.
2. CONTRACTOR TO VERIFY ALL DIMENSIONS APPLICABLE STATE AND LOCAL CODES AND ORDINANCES.
3. ALL ELECTRICAL OUTLETS AT NET AREAS (INCL. GARAGE) TO BE 6' 6".
4. ALL EXTERIOR ELECTRICAL OUTLETS TO BE WEATHER PROOF.
5. ALL GLAZING WITHIN 20" HORIZ. DISTANCE FROM EXTERIOR DOORS TO BE TEMPERED GLASS.
6. PLUMBING WALLS AT TOILETS TO BE 2X6 STUDS.
7. ALL DIMENSIONS ARE TO FACE OF STUD OR FACE OF BRICK. ALL DIMENSIONS ARE FOR NOMINAL 4" WALLS. 5'-1/2" MIN.
8. PROVIDE 110V. MIXED IN SERIES SMOKE DETECTORS OR FER. LOCAL CODE REQUIREMENTS.
9. ALL DOOR AND DOOR LOCATIONS INDICATED ON PLANS AT KIDN. & DOOR LOCATIONS.


SITE
PLAN
1" = 40'0"




© COPYRIGHT 2010 NO. 10 DESIGN GROUP

SHEET No.:

SP-1

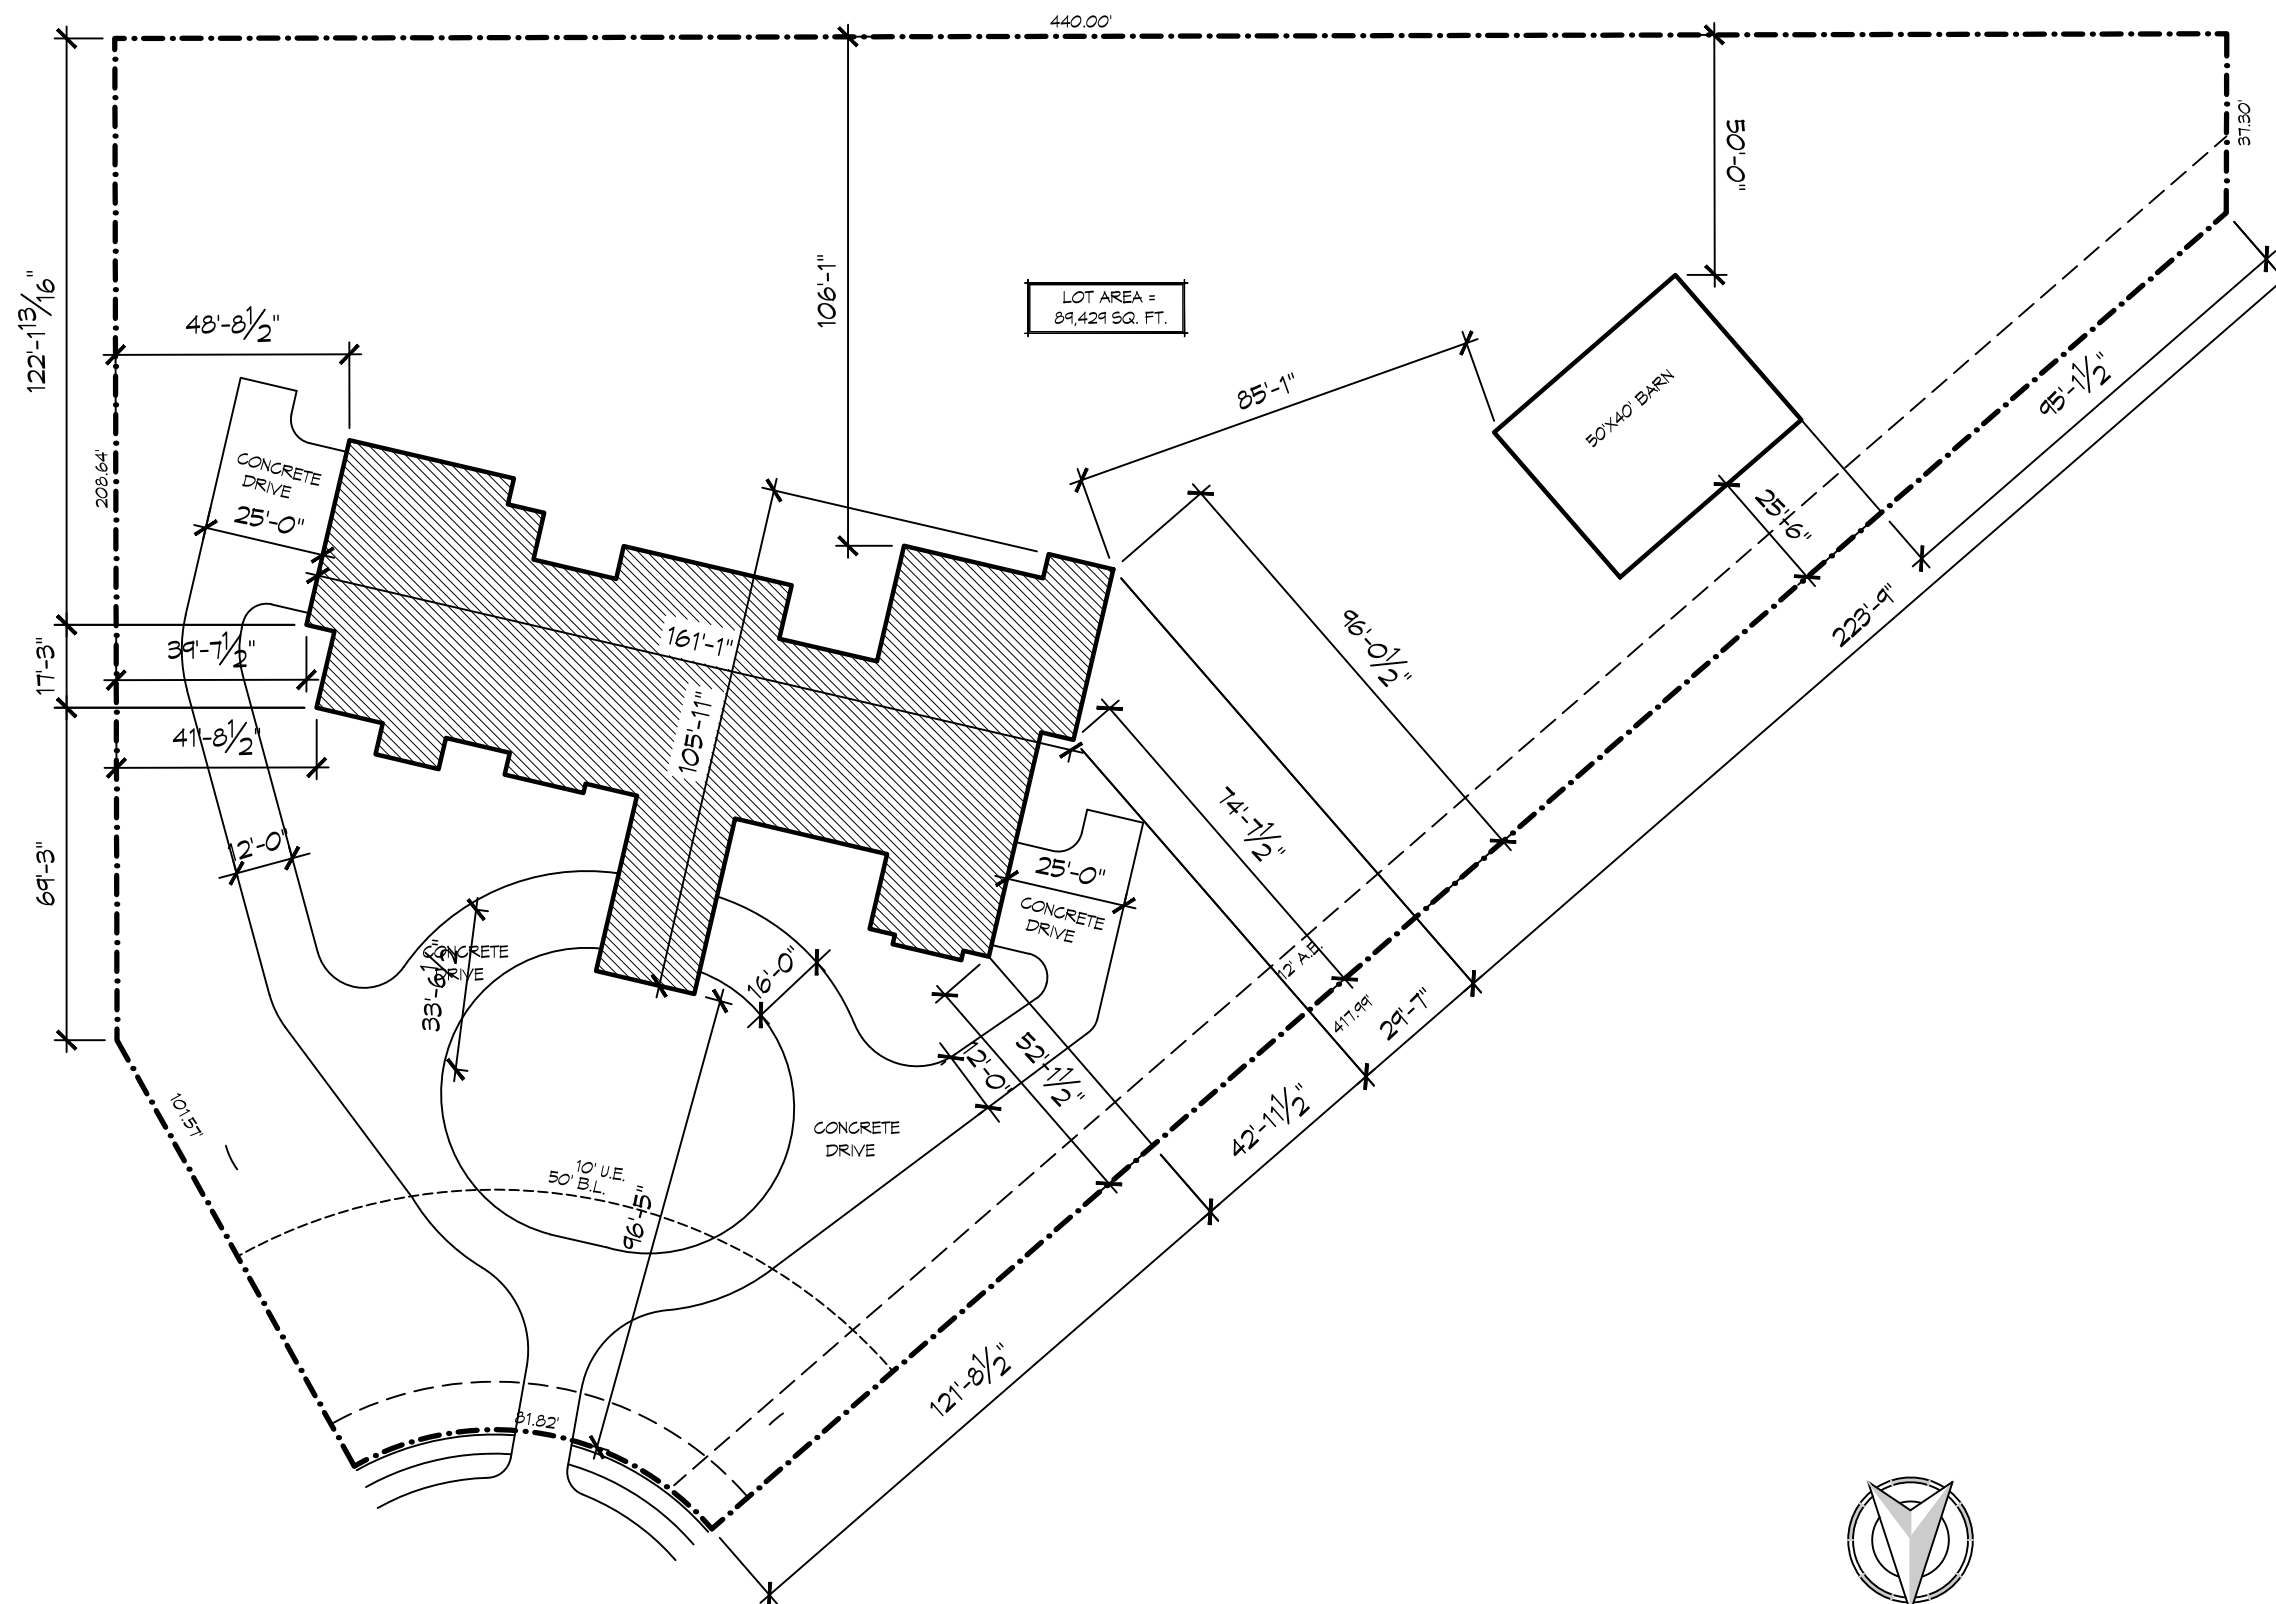

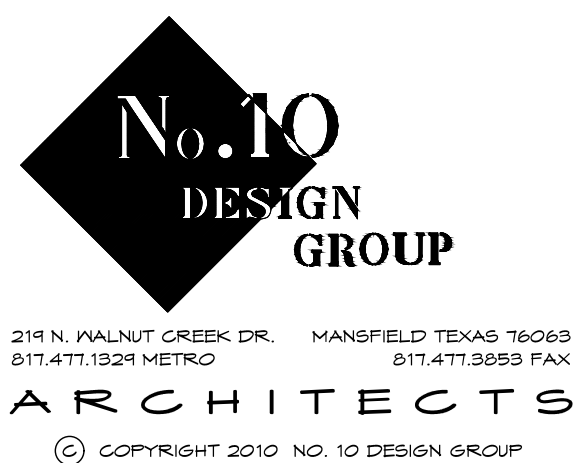

GENERAL NOTES:
1. CONTRACTOR TO VERIFY ALL DIMENSIONS PRIOR TO BEGINNING CONSTRUCTION. NOTIFY ARCHITECT OF ANY DISCREPANCIES IMMEDIATELY.
2. CONTRACTOR TO PROVIDE ALL APPLICABLE STATE AND LOCAL CODES AND ORDINANCES.
3. ALL ELECTRICAL OUTLETS AT RETAIL AREAS (INCL. GARAGE) TO BE S.P.I.
4. ALL EXTERIOR ELECTRICAL OUTLETS TO BE WEATHER PROOF.
5. ALL GLAZING WITHIN 20" HORIZ. DISTANCE FROM 5' AND EXTERIOR DOORS TO BE THERMALLY SEALED.
6. PLUMBING HALLS AT TOILETS TO BE 2x4 STUDS.
7. ALL DIMENSIONS ARE TO FACE OF STUD OR FACE OF BRICK. ALL DIMENSIONS ARE FOR NORMAL 4" W/8" (ACTUAL 3 1/2" (80%)) UNLESS OTHERWISE NOTED.
8. DETECTORS OR PER LOCAL CODE REQUIREMENTS.
9. WINDOW AND DOOR SIZES ARE AS INDICATED ON PLANS AT PDR. 6 DOOR LOCATIONS.

ELECTRICAL LEGEND

① 110V DUPLEX	⚡ LIGHT SWITCH
② 110V GFI	⚡ SURFACE MOUNT LIGHT
③ 220V	⚡ RECESSED CAN LIGHT
⚡ CARBON MONOXIDE DET.	⚡ WALL MOUNT LIGHT
⚡ SMOKE DETECTOR	⚡ VENT LIGHT
⚡ PHONE JACK	⚡ DIRECTIONAL CAN LIGHT
⚡ CABLE TV	⚡ DOUBLE FLOOD LIGHT
⚡ GAS	⚡ FAN ONLY
⚡ ELECTRICAL PANEL	⚡ FAN & LT. KIT
⚡ METER BASE	
1X4" 2X4" 4X4" FLOOR STRIP AS NOTED	



DATE: 2-15-14 PD1
3-22-14 PD2
4-4-14 PD3
4-24-14 S/O
5-5-14 S/O2
5-7-14 FIN





916 DOVE CREEK CT.
LOT 18 BLOCK A
HATCREEK EST.
BARTONVILLE, TX
DENTON COUNTY

MR AND MRS
MOLLO

190248

SHEET Title:
ELECTRICAL PLAN
SCALE: 1/4" = 10"

SHEET No.:
E1-1

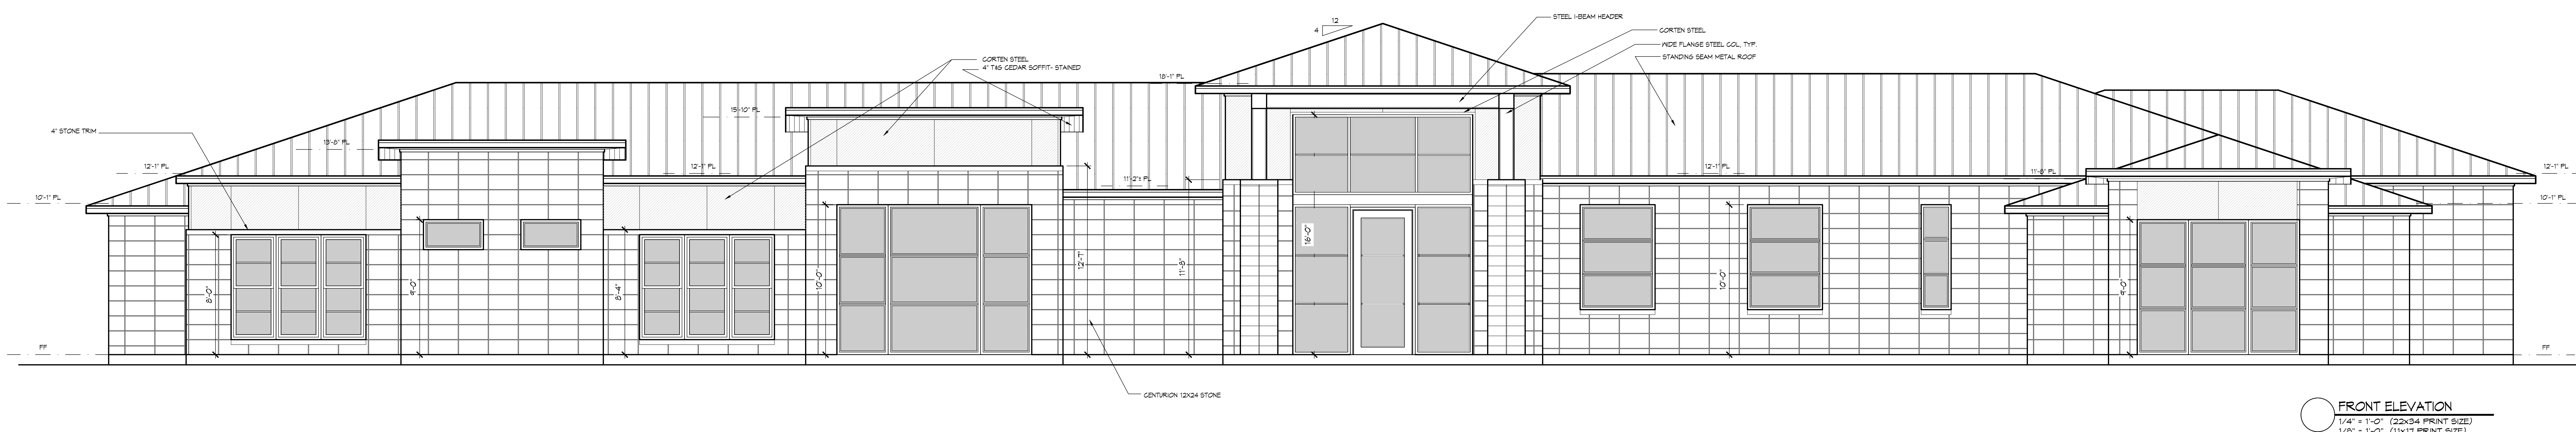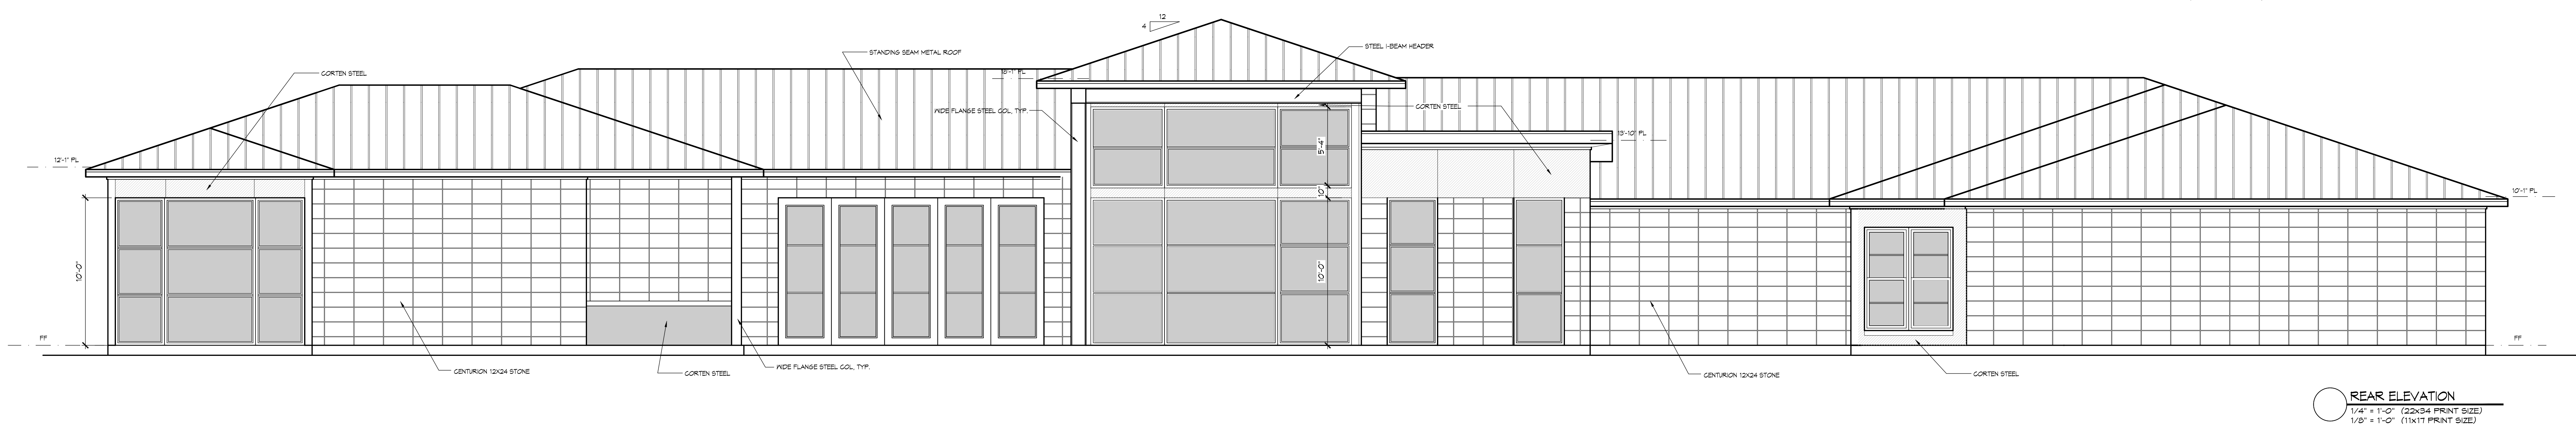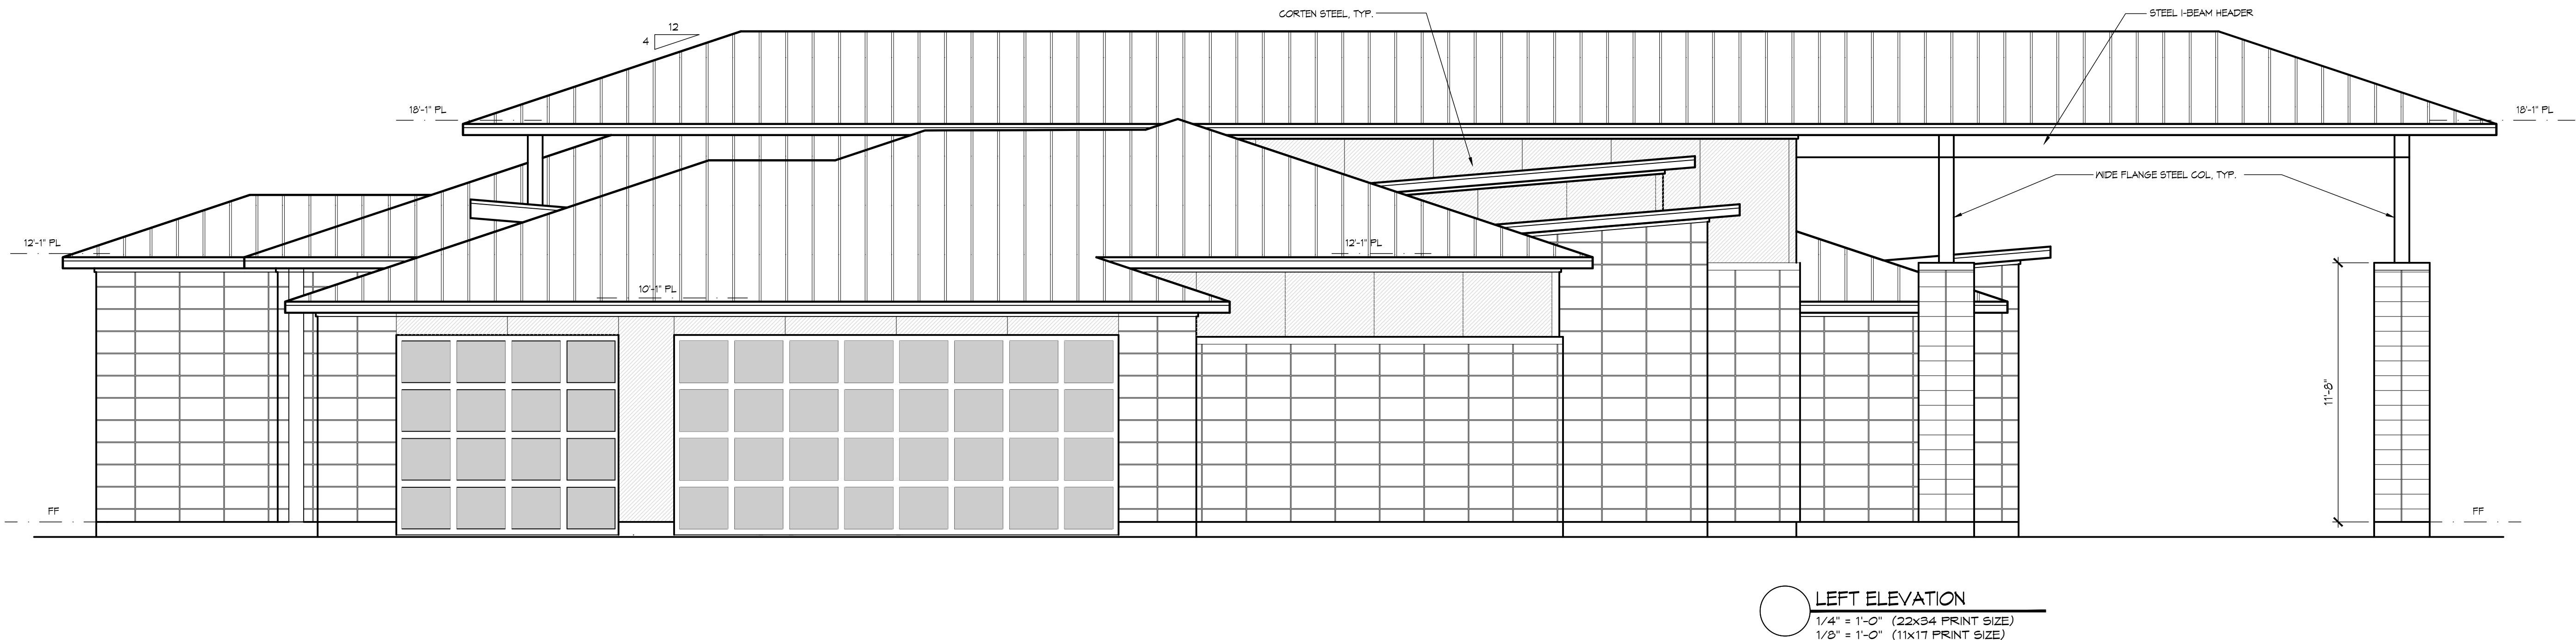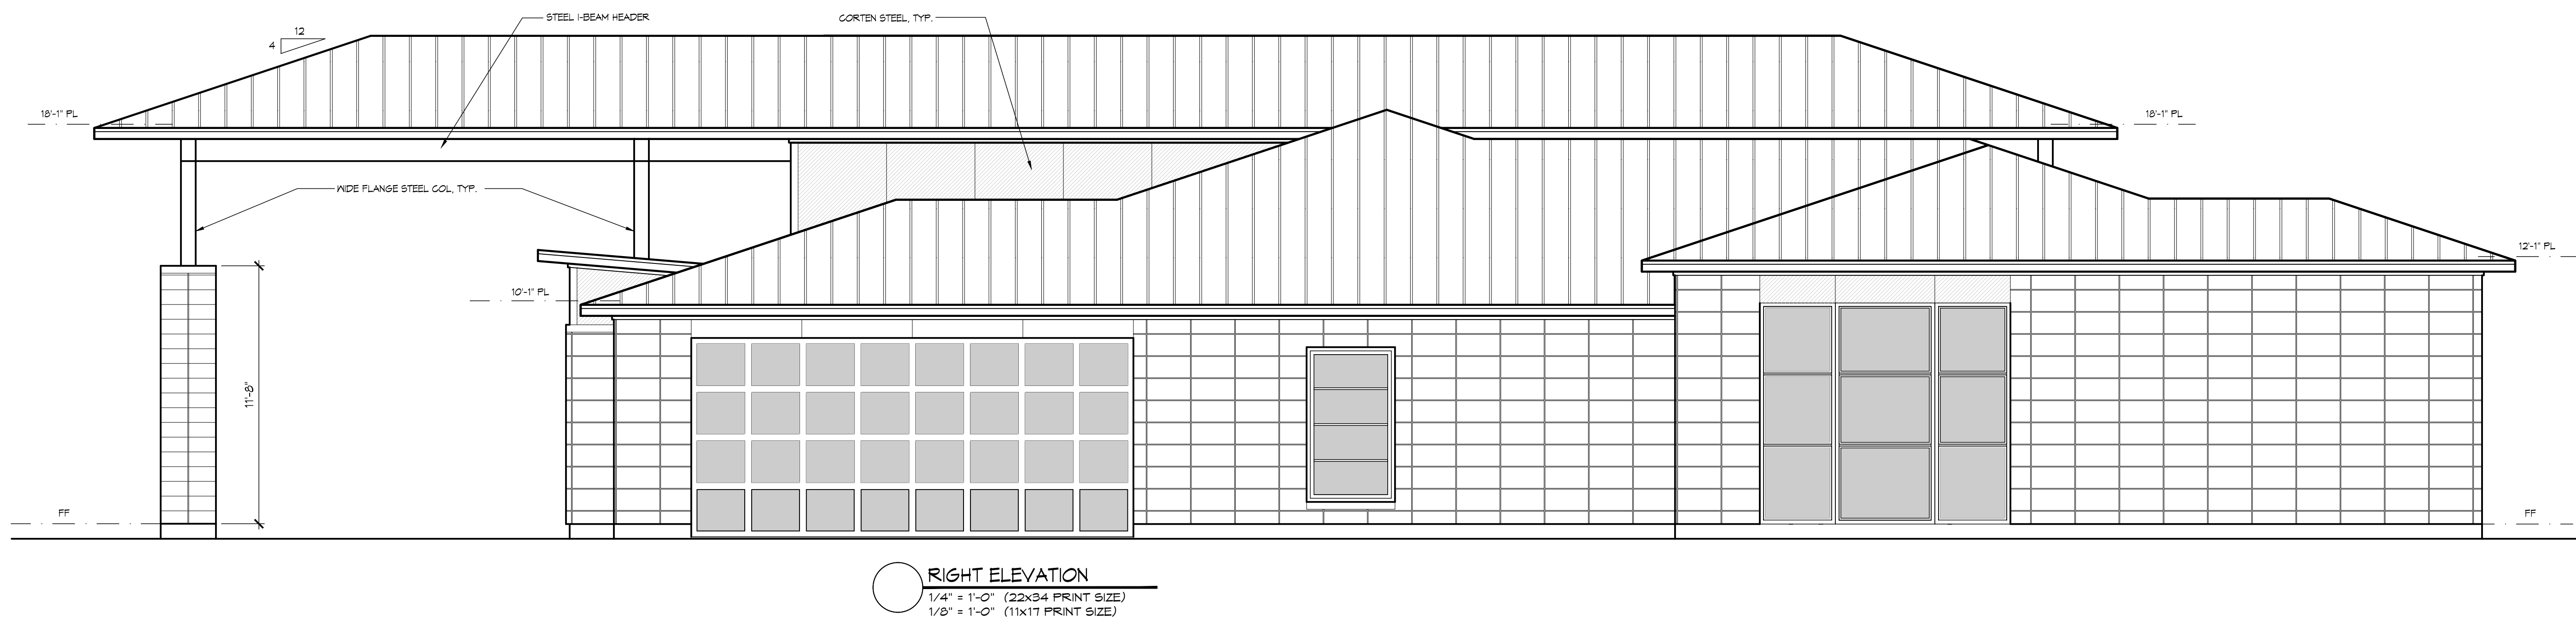

GENERAL NOTES:
1. CONTRACTOR TO VERIFY ALL DIMENSIONS PRIOR TO BEGINNING CONSTRUCTION. NOTIFY ARCHITECT OF ANY DISCREPANCIES IMMEDIATELY.
2. CONTRACTOR TO PROVIDE ALL APPLICABLE STATE AND LOCAL CODES AND ORDINANCES.
3. ALL ELECTRICAL OUTLETS AT NET AREA SHALL BE 6\"/>

ELECTRICAL LEGEND

① 110V DUPLEX	⚡ LIGHT SWITCH
② 110V GFI	⚡ SURFACE MOUNT LIGHT
③ 220V	⚡ RECESSED CAN LIGHT
④ CARBON MONOXIDE DET.	⚡ WALL MOUNT LIGHT
⑤ SMOKE DETECTOR	⚡ VENT LIGHT
⑥ PHONE JACK	⚡ DIRECTIONAL CAN LIGHT
⑦ CABLE TV	⚡ DOUBLE FLOOD LIGHT
⑧ GAS	
⚡ ELECTRICAL PANEL	⚡ FAN ONLY
⚡ METER BASE	⚡ FAN & LT. KIT
11x4\"/>	



DATE: 2-15-19 PD1
4-4-19 PD2
4-4-19 PD3
4-24-19 S/O
5-6-19 S/O
5-7-19 FIN

916 DOVE CREEK CT.
LOT 18 BLOCK A
HATCREEK EST.
BARTONVILLE, TX
DENTON COUNTY


MR AND MRS
MOLLO

190248

SHEET Title:
ELEVATIONS

SCALE: 1/4" = 10"

SHEET No.:
A2-1

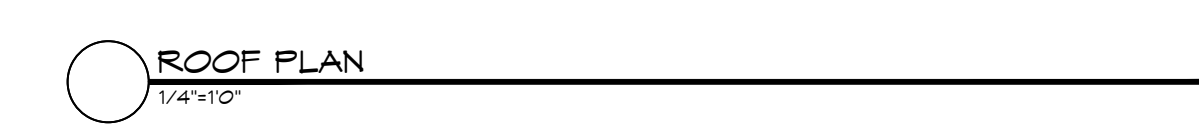

3 GATHERING RM. ELEVATION
1/4" = 1'-0"

