

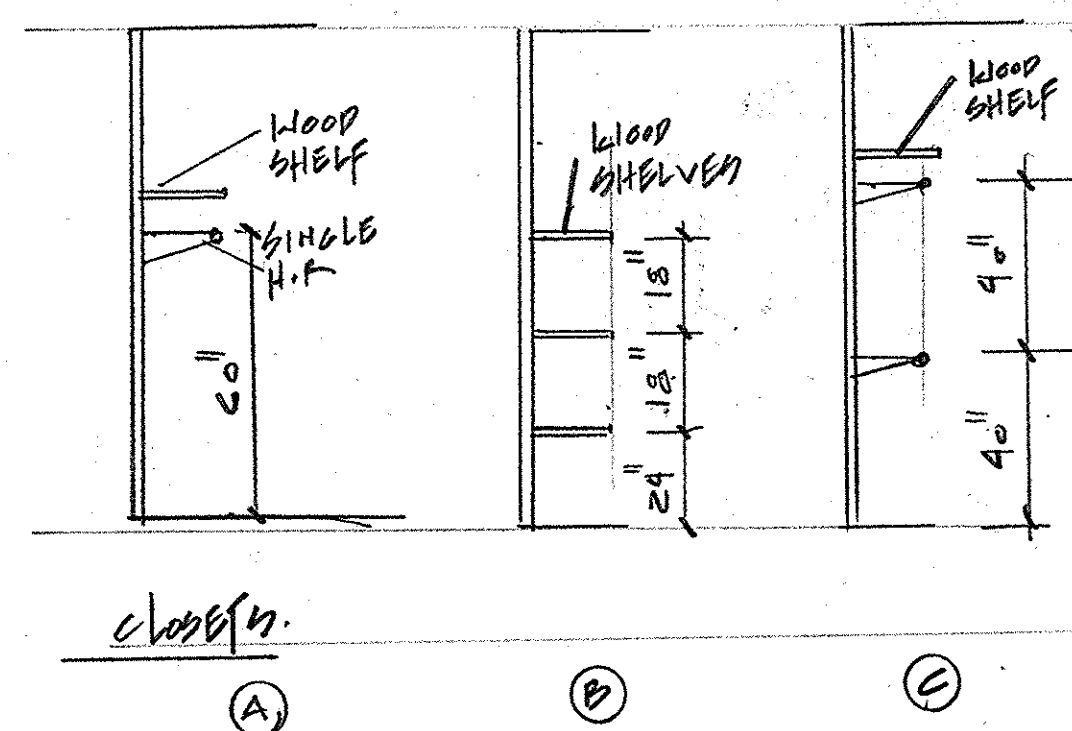
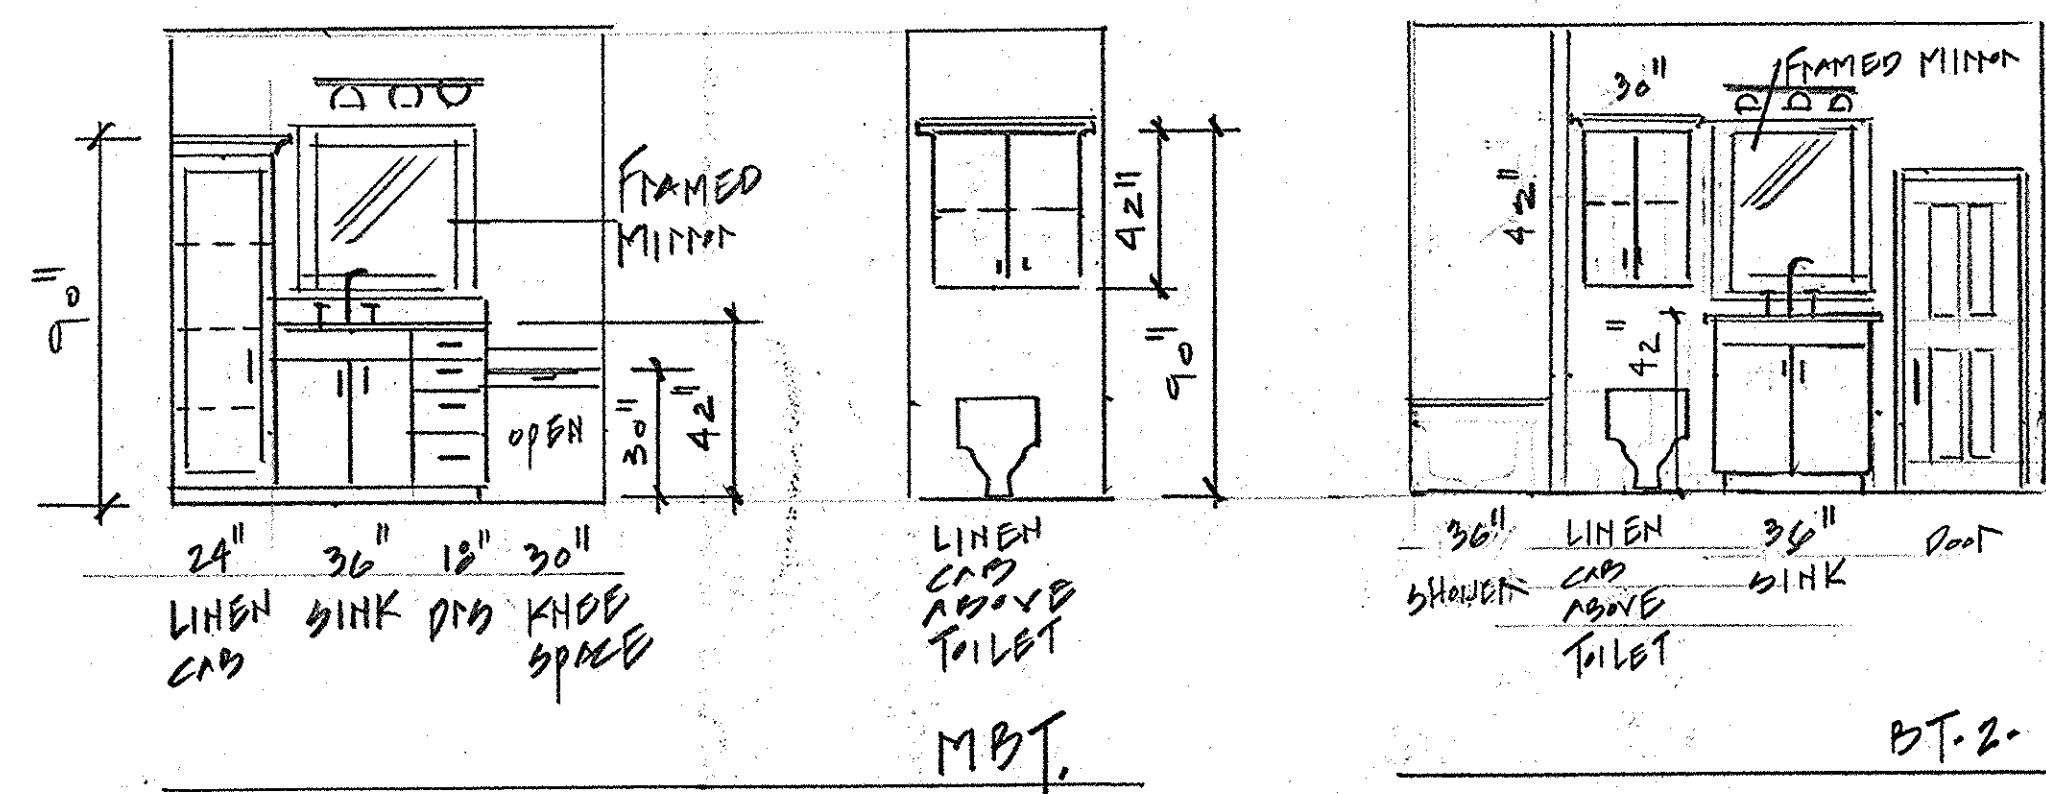


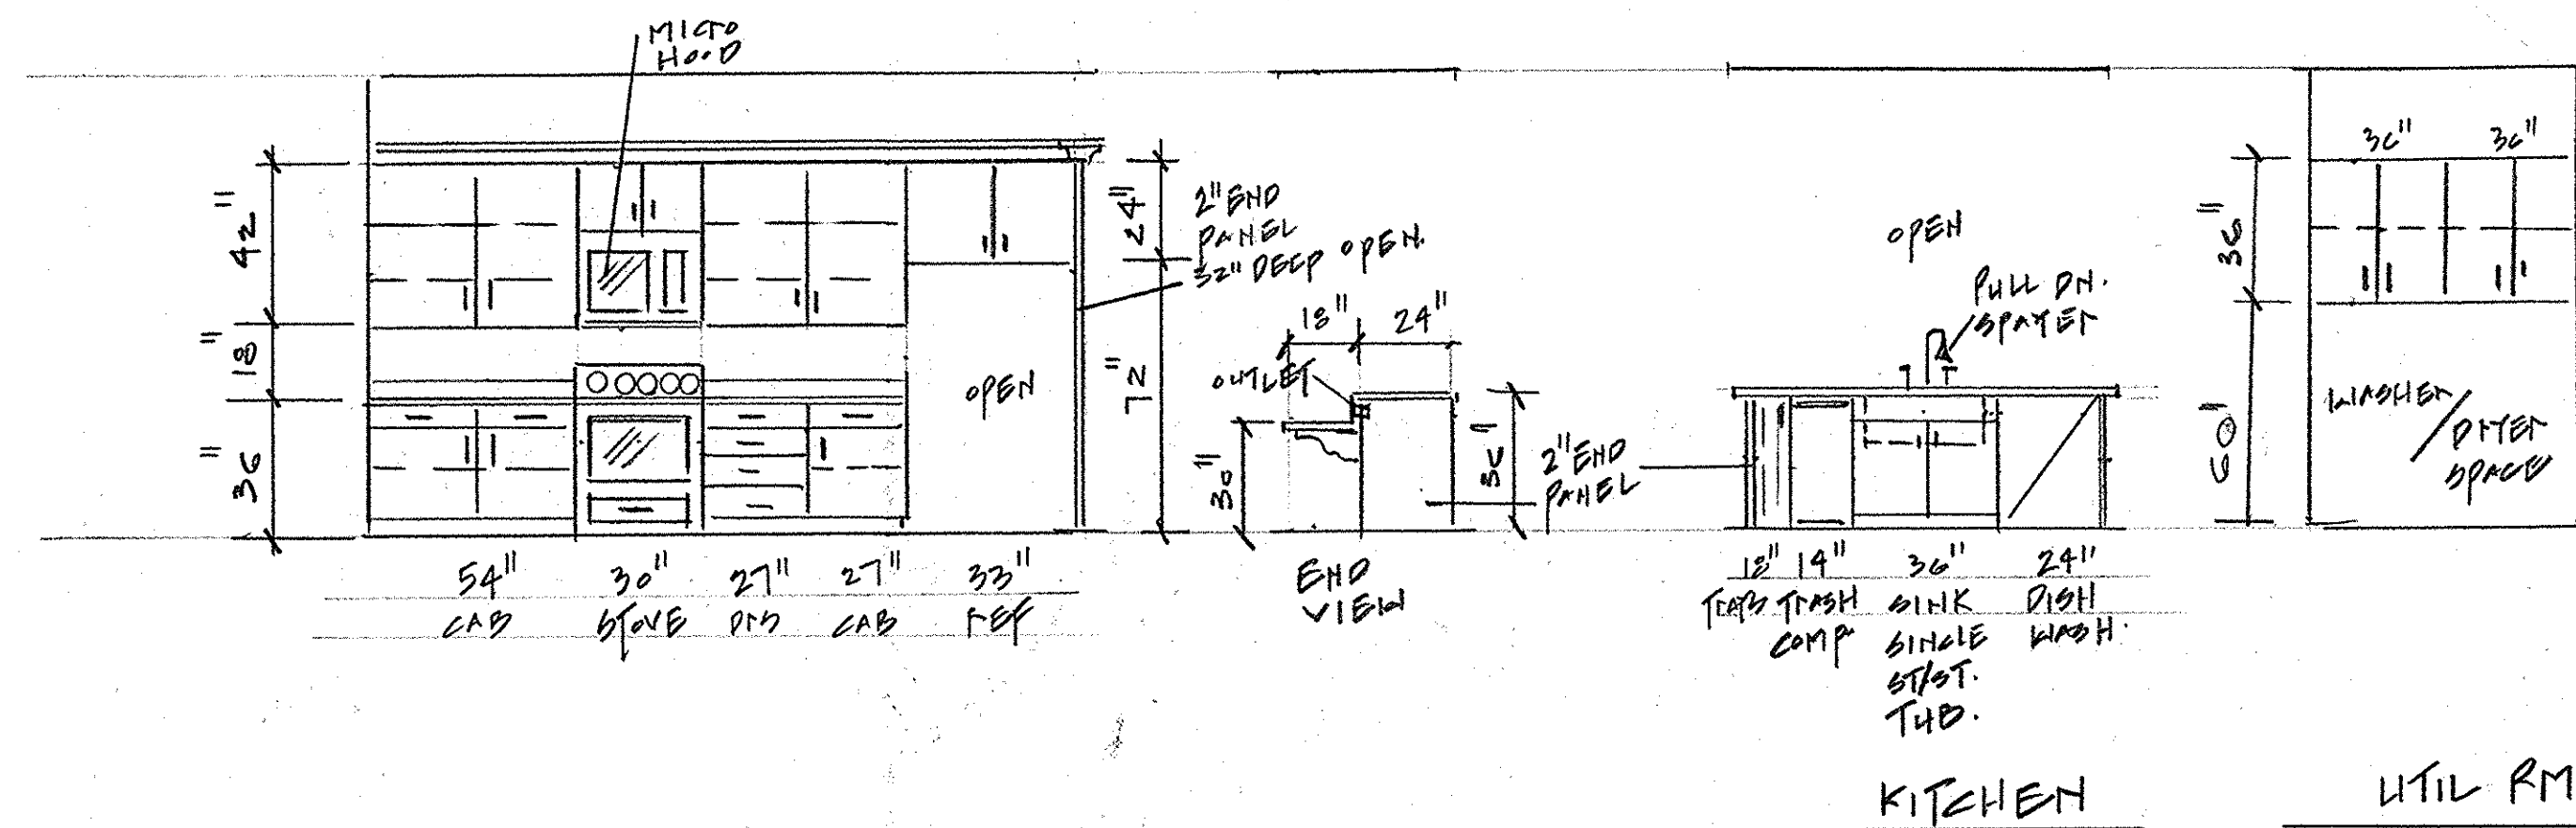

ELECTRICAL LEGEND.

- ⊕ SURFACE MOUNTED FIXTURE
- RECESSED LIGHT FIXTURE
- ⊕ WALL MOUNTED FIXTURE
- ✱ FAN W/ LIGHT KIT
- ⊕ H.V. HEAT-VENT-LIGHT FIXTURE
- ⊕ 110 V OUTLET
- ⊕ 220 V OUTLET
- ⊕ 110 V WATERPROOF OUTLET
- ⊕ TELEPHONE JACK
- ⊕ SMOKE DETECTOR
- ⊕ CARBON MONOXIDE DETECTOR
- ⊕ SUPPLY REGISTER EACH BATH

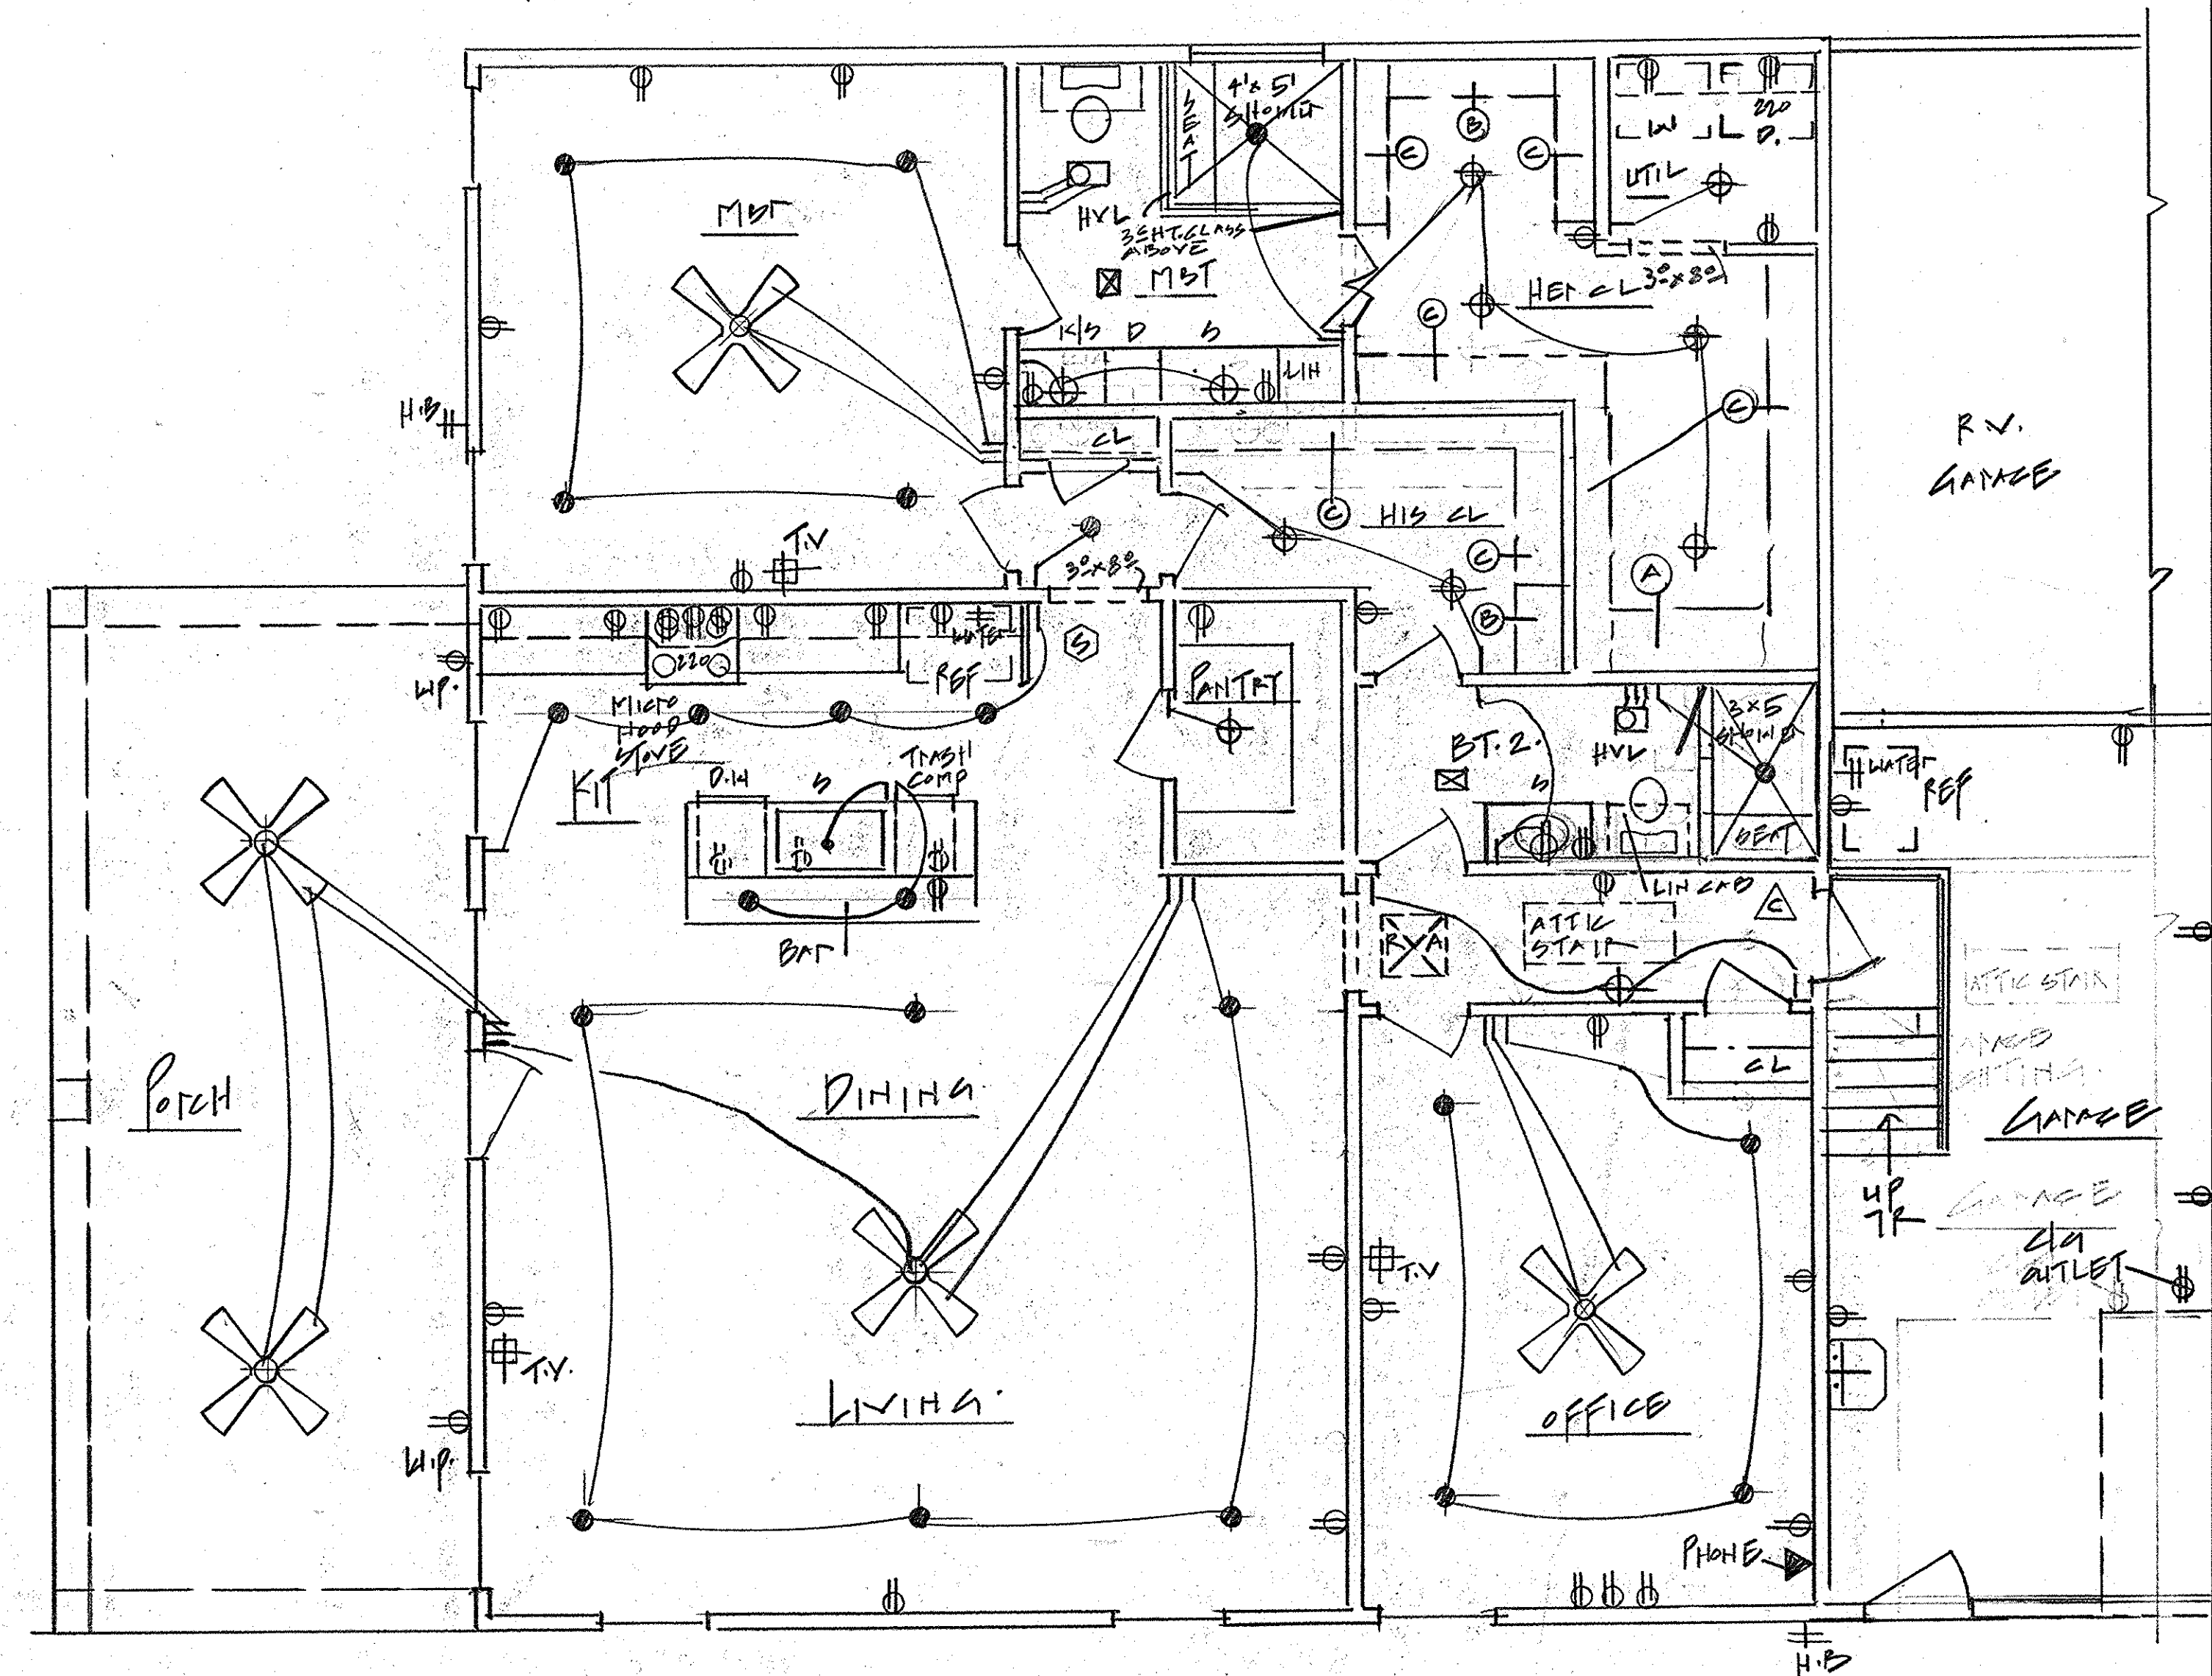

ELECTRICAL/CABINETS/CLOSETS		
SCALE:	APPROVED BY:	DRAWN BY:
DATE:		REVISED:
FINAL ELECTRICAL		
AUG 13, 2019		DRAWING NUMBER 2.0 F2