



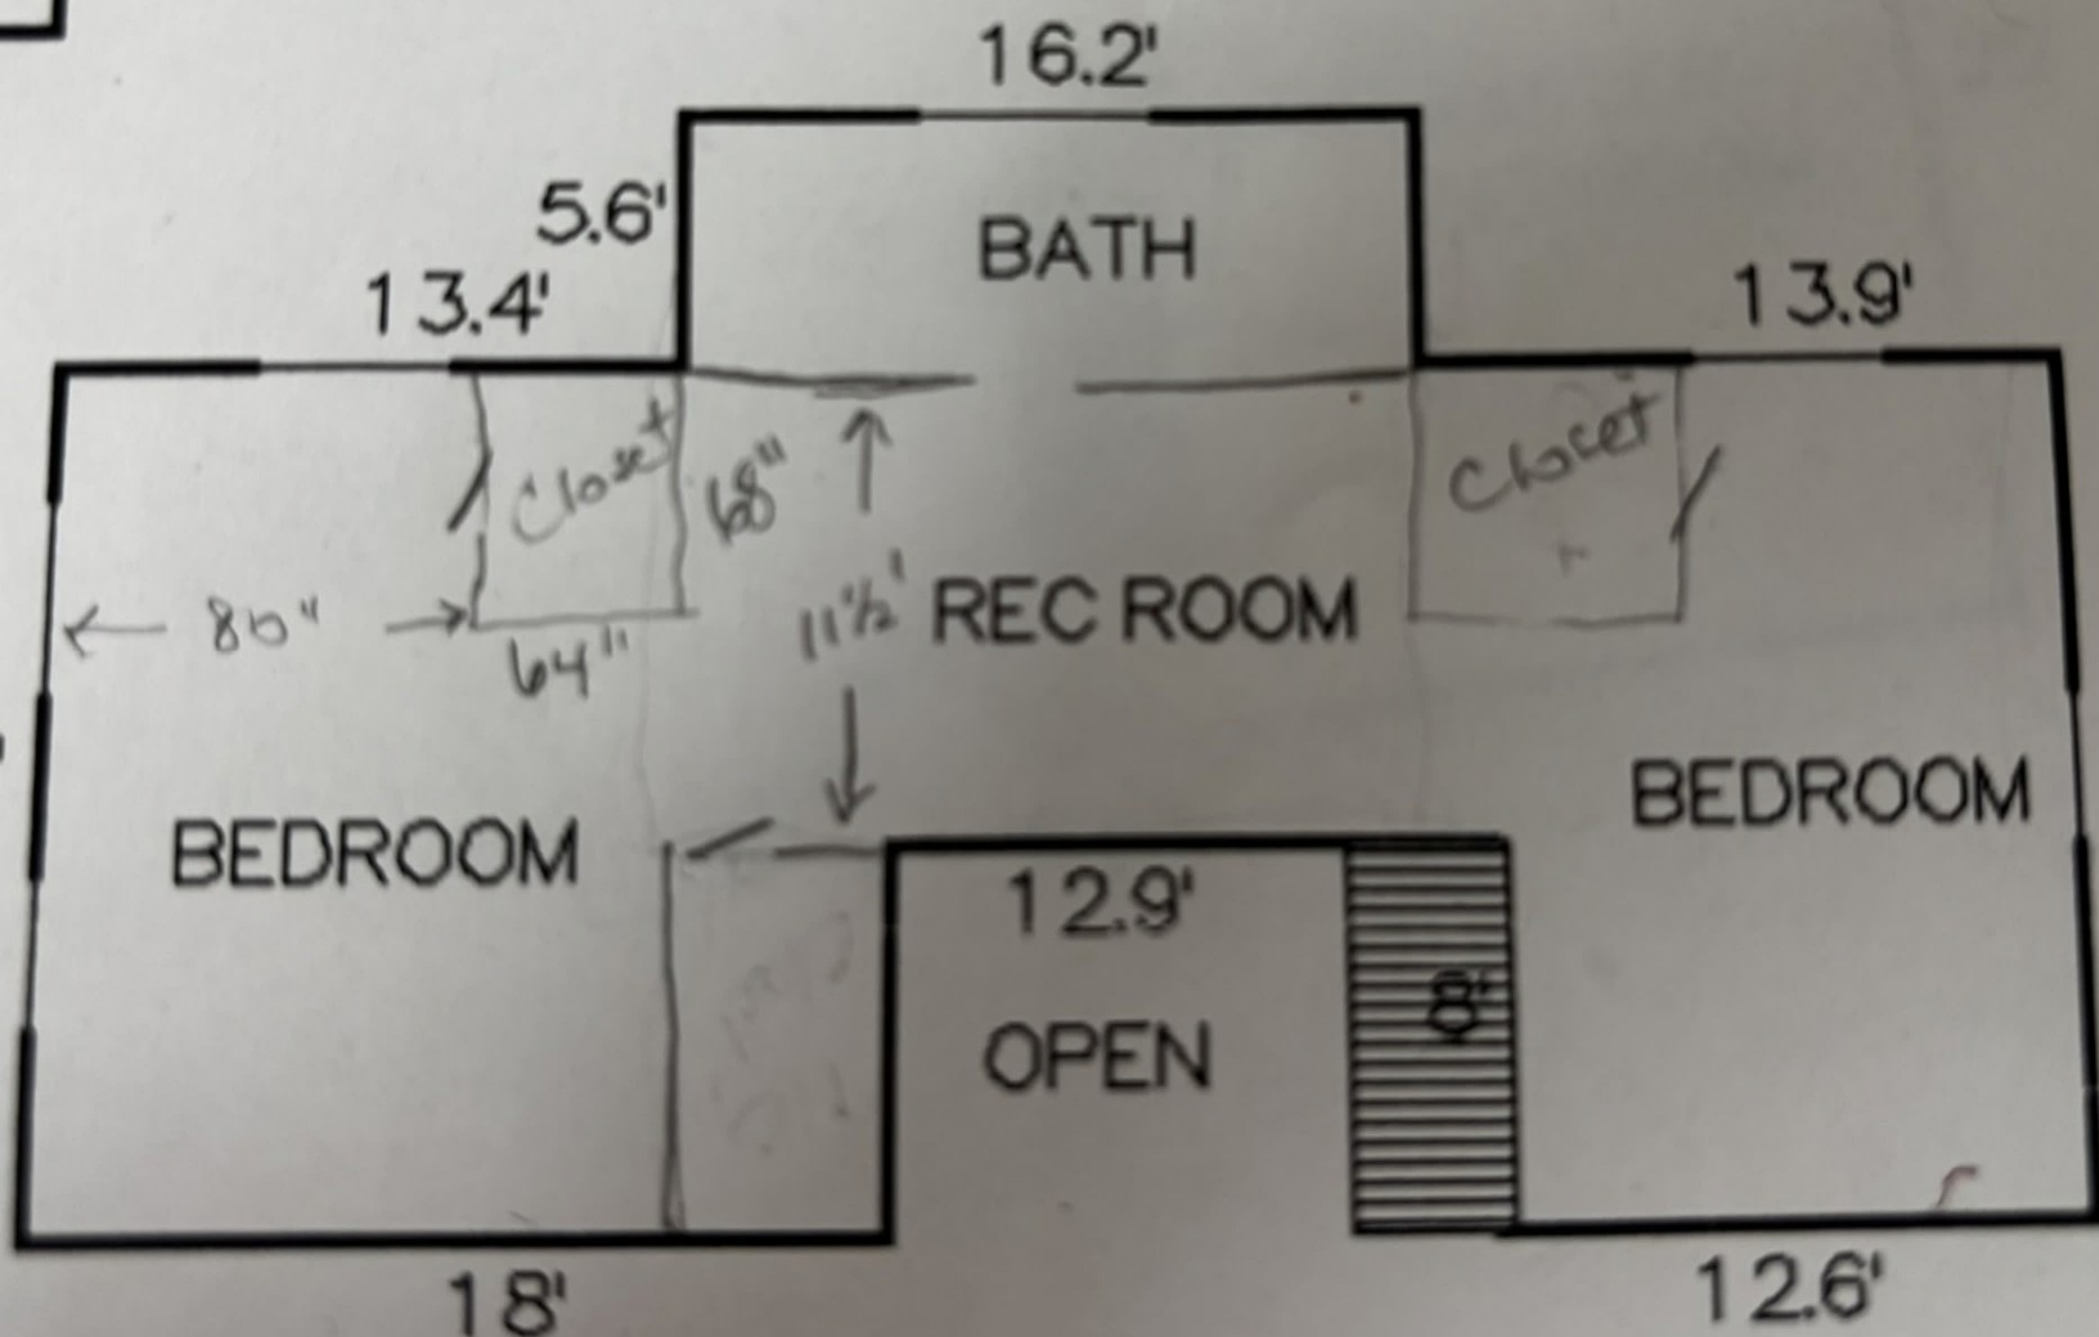

SECOND FLOOR

SCALE: 1 inch = 10 feet

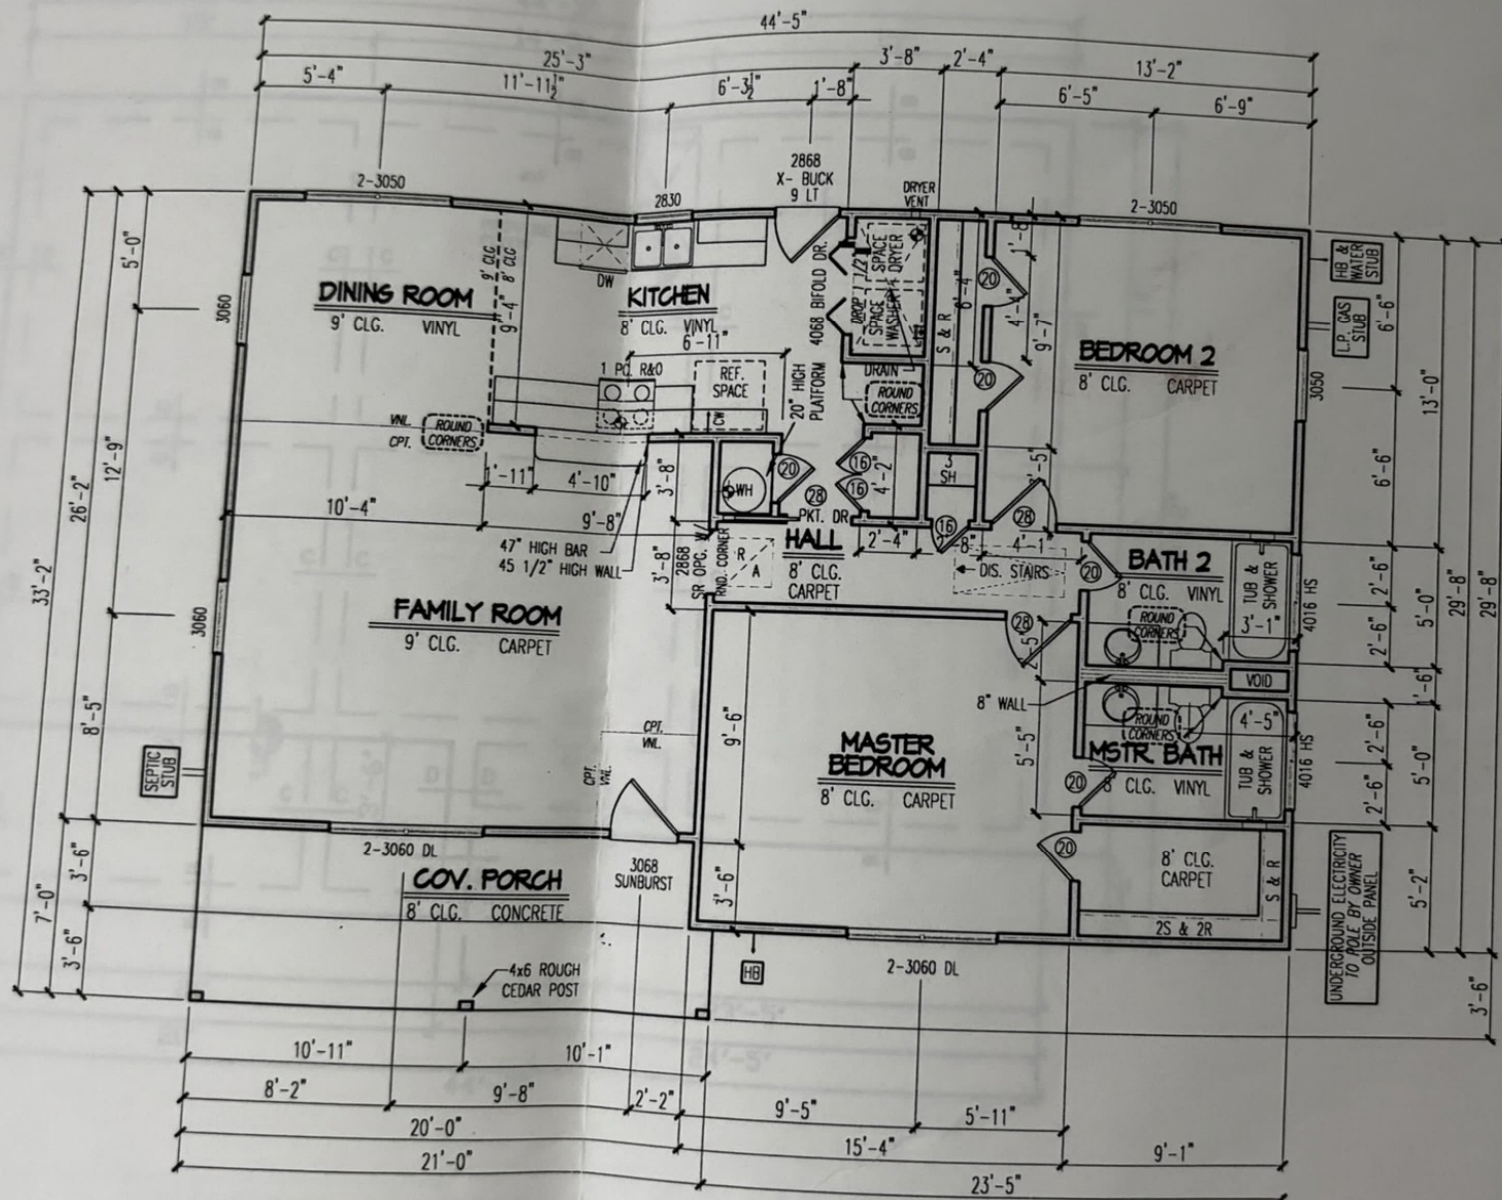

WATER HEATER CLOSET NOTES:
 WEATHERSTRIP DOOR AND
 PROVIDE OUTSIDE COMBUSTIBLE AIR

FLOOR PLAN

Scale: 1/8" = 1'-0"