

CROSS RESIDENCE



STAMP

CONSULTANT

CROSS RESIDENCE
2568 EATON STREET
EDGEWATER, CO 80214

DRAWING INDEX

- A0.1 DRAWING INDEX / GENERAL NOTES /
DESIGN CRITERIA / VICINITY PLAN
- A0.2 SITE PLAN
- A1.0 CONSTRUCTION PLANS
- A1.1 ROOF PLAN AND SCHEDULES
- A2.0 ELEVATIONS
- A3.0 BUILDING SECTION
- A3.1 STAIR SECTION

E1.0 ELECTRICAL AND LIGHTING PLANS

DESIGN CRITERIA

INTERNATIONAL RESIDENTIAL CODE (IRC) – 2021
INTERNATIONAL BUILDING CODE (IBC) – 2021
INTERNATIONAL MECHANICAL CODE (IMC) – 2021
INTERNATIONAL PLUMBING CODE (IPC) – 2021
INTERNATIONAL FIRE CODE – 2021
INTERNATIONAL ENERGY CONSERVATION CODE – 2021
NATIONAL ELECTRICAL CODE (NEC) – 2020

GENERAL NOTES

- DIMENSIONS TAKE PRECEDENCE OVER DRAWINGS – DO NOT SCALE. ALL DIMENSIONS GIVEN TO FACE OF STUD.
- ALL WORK MUST BE PERFORMED IN COMPLIANCE WITH ALL STATE AND LOCAL CODES. SECURE ALL PERMITS AND APPROVALS PRIOR TO ANY CONSTRUCTION.
- CONTRACTOR MUST EXAMINE AND VERIFY ALL DIMENSIONS AND CONDITIONS BOTH ON THE PLAN AND IN THE FIELD, AND BE RESPONSIBLE FOR ANY ADJUSTMENTS AND/OR CORRECTIONS.
- OWNER TO PROVIDE:
SOIL TEST
MECHANICAL PLANS
EXACT SPECIFICATIONS
COLOR SELECTIONS
LANDSCAPE PLANS
FIELD SUPERVISION
- CONTRACTOR MUST VERIFY EXISTING SOIL CONDITIONS AND MUST NOTIFY THE OWNER OF ANY DISCREPANCIES OF THE SOILS REPORT. PROVIDE CONTROL JOINTS AT ALL SLAB CONDITIONS.
- PROVIDE TEMPERED GLASS AT SLIDING DOORS AND AREAS SUBJECT TO HUMAN IMPACT MUST BE PER LOCAL CODE. SAFETY GLAZING IS REQUIRED IN WINDOWS WITHIN A 24" ARC OF A DOOR AND LESS THAN 60" ABOVE THE FLOOR WITHIN 3' OF STAIRS AND LANDINGS WHEN THE BOTTOM EDGE IS LESS THAN 60" ABOVE THE FLOOR (5' IN ANY DIRECTION FROM THE BOTTOM TREAD) AND ADJACENT TO BATHTUBS OR SHOWERS WHEN LESS THAN 60" ABOVE THE WALKING/STANDING SURFACE. (SEE SEC. R308.4 FOR FURTHER INFORMATION)
- ALL EXTERIOR DOORS AND DOORS LEADING TO UNHEATED AREAS ABOVE GRADE MUST BE WEATHER STRIPPED.
- INSULATION PER SEC. N1102
MIN. R-20+5 IN ALL EXTERIOR WALLS
MIN. R-60 IN ALL ROOF AREAS
MIN. R-30 IN ALL JOIST SPACES
MIN. R-19 IN ALL BASEMENT WALLS
MIN. R-19 IN ALL CRAWLSPACE AREAS
- PROVIDE COMBUSTION AIR TO FURNACE AND WATER HEATER PER LOCAL BUILDING CODE.
- EXTERIOR OPENINGS EXPOSED TO WEATHER (ie CONCRETE SLAB) MUST BE FLASHED TO PREVENT WATER PENETRATING THE FOUNDATION.
- PROVIDE ROOF VENTILATION AS REQUIRED PER SECTION R806.
- PROVIDE 5/8" TYPE-X GYP. BOARD UNDER STAIRS IF SPACE IS ENCLOSED.
- INSTALL GUTTERS AT ALL HORIZONTAL FASCIAS PER CODE. DOWNSPOUTS TO HAVE 5' ADJUSTABLE EXTENDERS TYP. ALL EXPOSED METAL MUST BE PAINTED TO MATCH COLOR OF SURFACE.
- ALL TUB AND SHOWER ENCLOSURES MUST BE FINISHED WITH NON-ABSORBENT SURFACES AND FIXTURES PENETRATIONS TO BE SEALED.
- SHOWERS AND TUB/SHOWER COMBINATIONS MUST BE PROVIDED WITH INDIVIDUAL CONTROL VALVES OF THE PRESSURE BALANCE OR THE THERMOSTATIC MIXING VALVE TYPE. HANDLE POSITION STOPS ARE REQUIRED AND MUST BE ADJUSTED PER THE MFG'S INSTRUCTIONS TO DELIVER A MAXIMUM MIXED WATER SETTING OF 120 DEGREES PER SEC. P2713.
- EVERY SLEEPING ROOM MUST HAVE ONE WINDOW OR EXTERIOR DOOR APPROVED FOR EMERGENCY EXIT OR RESCUE. WHERE SUCH WINDOWS ARE PROVIDED, THEY MUST HAVE A SILL HEIGHT OF NOT MORE THAN 44" ABOVE THE FLOOR AND THE OPENING MUST PROVIDE A MINIMUM CLEAR WIDTH OF 20", A MINIMUM CLEAR HEIGHT OF 24", AND CLEAR OPENING OF 5.7 SQ.FT. PER SECTION R310.
- MAXIMUM BASEMENT SILL HEIGHT MUST BE 44" ABOVE FLOOR, AND MAX. WELL DEPTH MUST BE 44" BELOW GRADE. EGRESS WINDOWS FROM THE BASEMENT MUST BE PROVIDED WITH AN EGRESS WINDOW WELL IF THE WINDOW HEIGHT IS BELOW THE ADJOINING FINISHED GRADE. THE WINDOW WELL MUST HAVE A MIN. CLEAR AREA OF 9 SQ.FT. AND A MIN. HORIZONTAL PROJECTION AND WIDTH OF 36". IF THE WINDOW WELL IS GREATER THEN 44" DEEP, IT MUST BE EQUIPPED WITH A PERMANENTLY AFFIXED LADDER OR STEPS USABLE WITH THE WINDOW IN THE FULLY OPEN POSITION OR ENCROACHED MORE 6" INTO THE CLEAR AREA, PER SECTION R310.
- PROVIDE 4" DIA. MOISTURE EXHAUST DUCT FOR CLOTHES DRYER. LENGTH MUST NOT EXCEED 35'. SEE SECTION M1502.
- PROVIDE ACCESS PANEL TO WHIRLPOOL TUB PER SEC. P2720.1.
- ALL BASEMENT DAMP-PROOFING TO BE PER SECTION R406 AND SPRAYED ON BASEMENT AND CRAWLSPACE EXTERIOR SURFACES.
- BATHROOMS AND WATER CLOSET AREAS MUST BE VENTILATED PER SECTION M1505.
- FIREPLACES MUST BE INSTALLED IN ACCORDANCE WITH MANUFACTURER'S INSTALLATION INSTRUCTIONS. ONLY FIREPLACE AND CHIMNEY COMPONENTS LISTED BY A NATIONALLY RECOGNIZED TESTING AGENCY ARE ACCEPTABLE.
- FUEL OR GAS FIRED EQUIPMENT (FURNACE, WATER HEATER, ETC.) MUST BE PROVIDED WITH ADEQUATE OUTSIDE COMBUSTION AIR. THE MIN. SIZE AND NUMBER OF THE DUCTS IS DETERMINED BY THE COMBINED BTU RATINGS OF THE EQUIPMENT SERVED. SEE CHAPTER 17, IRC FOR FURTHER INFORMATION.

VICINITY PLAN



FEB. 2, 2025

DRAWING SET DATE

Issues/Revisions 1 = Issue
Δ = Revision

NO. DATE PURPOSE BY CHK

NO.	DATE	PURPOSE	BY	CHK

Proj. #:

Scale:

File:

Sheet Title

DRAWING INDEX /
GENERAL NOTES /
DESIGN CRITERIA

Sheet No. of

A0.1

STAMP

CONSULTANT


CROSS RESIDENCE

2568 EATON STREET
EDGEWATER, CO 80214

FEB. 2, 2025

DRAWING SET DATE				
Issues/Revisions		1	= Issue	
		Δ	= Revision	
NO.	DATE	PURPOSE	BY	CHK

Proj. #:
Scale: 1"=10'
File:
Sheet Title SITE PLAN
Sheet No. of
A0.2

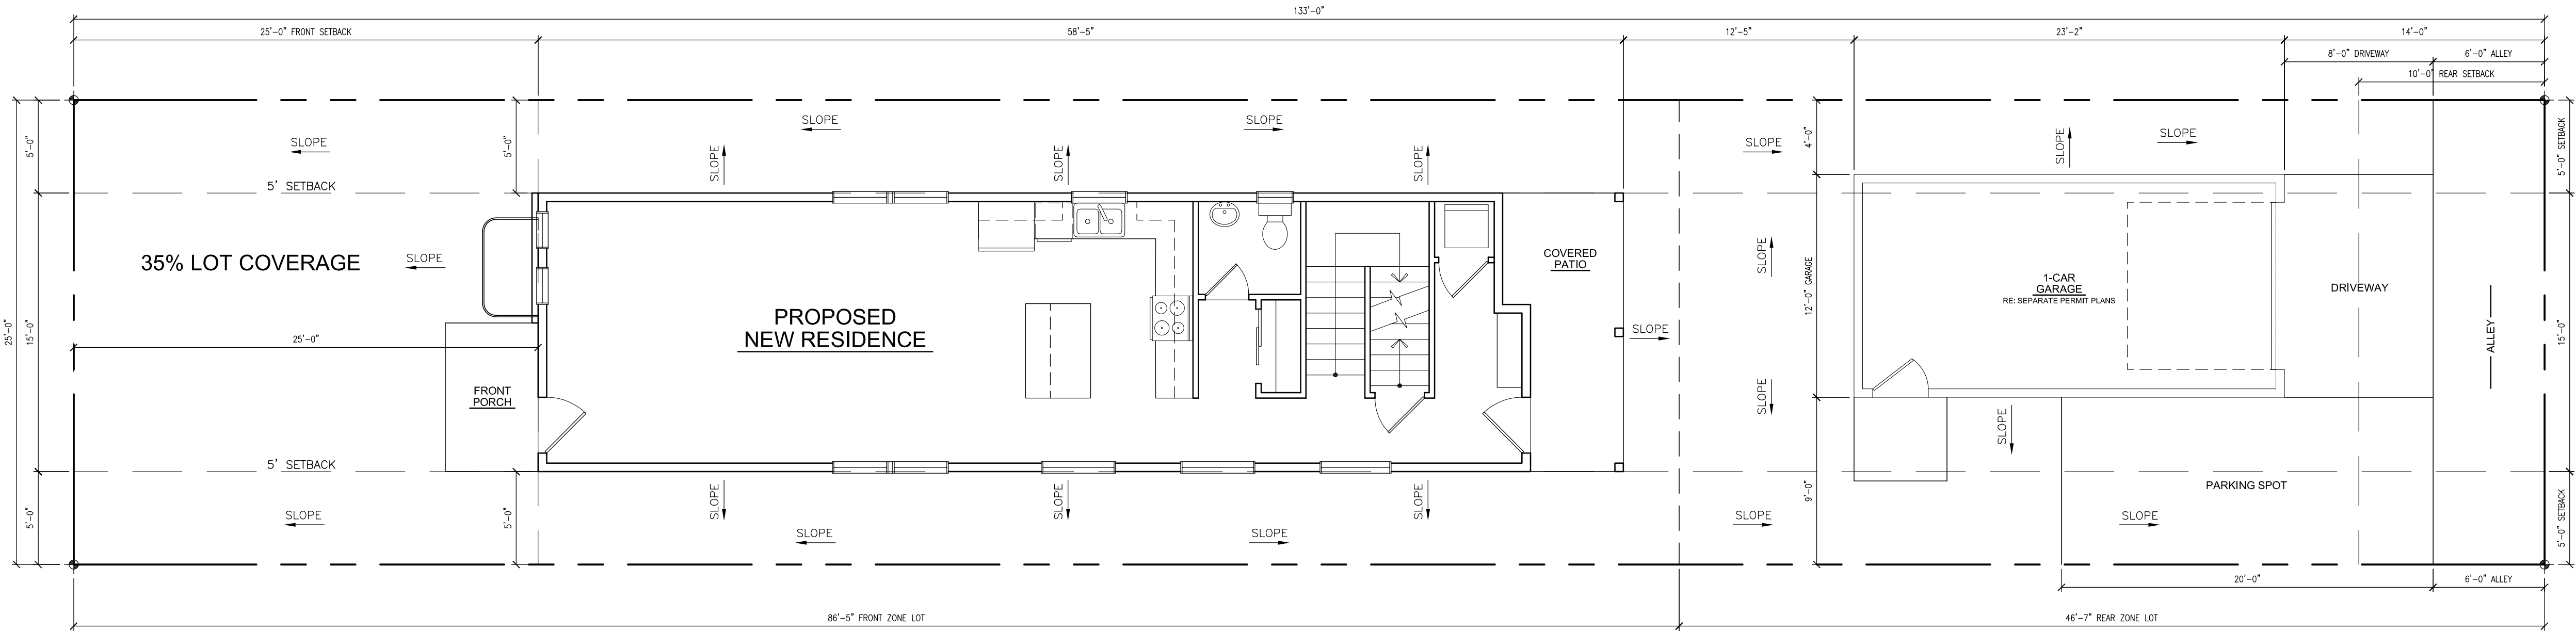

1

A0.2

SITE PLAN

SCALE: 3/16"=1'-0"

NORTH

3,325 SQ. FT. LOT
1,165 LOT COVERAGE
35% LOT COVERAGE

STAMP

CONSULTANT

CROSS RESIDENCE
2568 EATON STREET
EDGEWATER, CO 80214

FEB. 2, 2025

DRAWING SET DATE

Issues/Revisions 1 = Issue
Δ = Revision

NO. DATE PURPOSE BY CHK

Proj. #:


Scale: 1/4"=1'-0"

File:


Sheet Title
CONSTRUCTION PLANS

Sheet No. of


A1.0

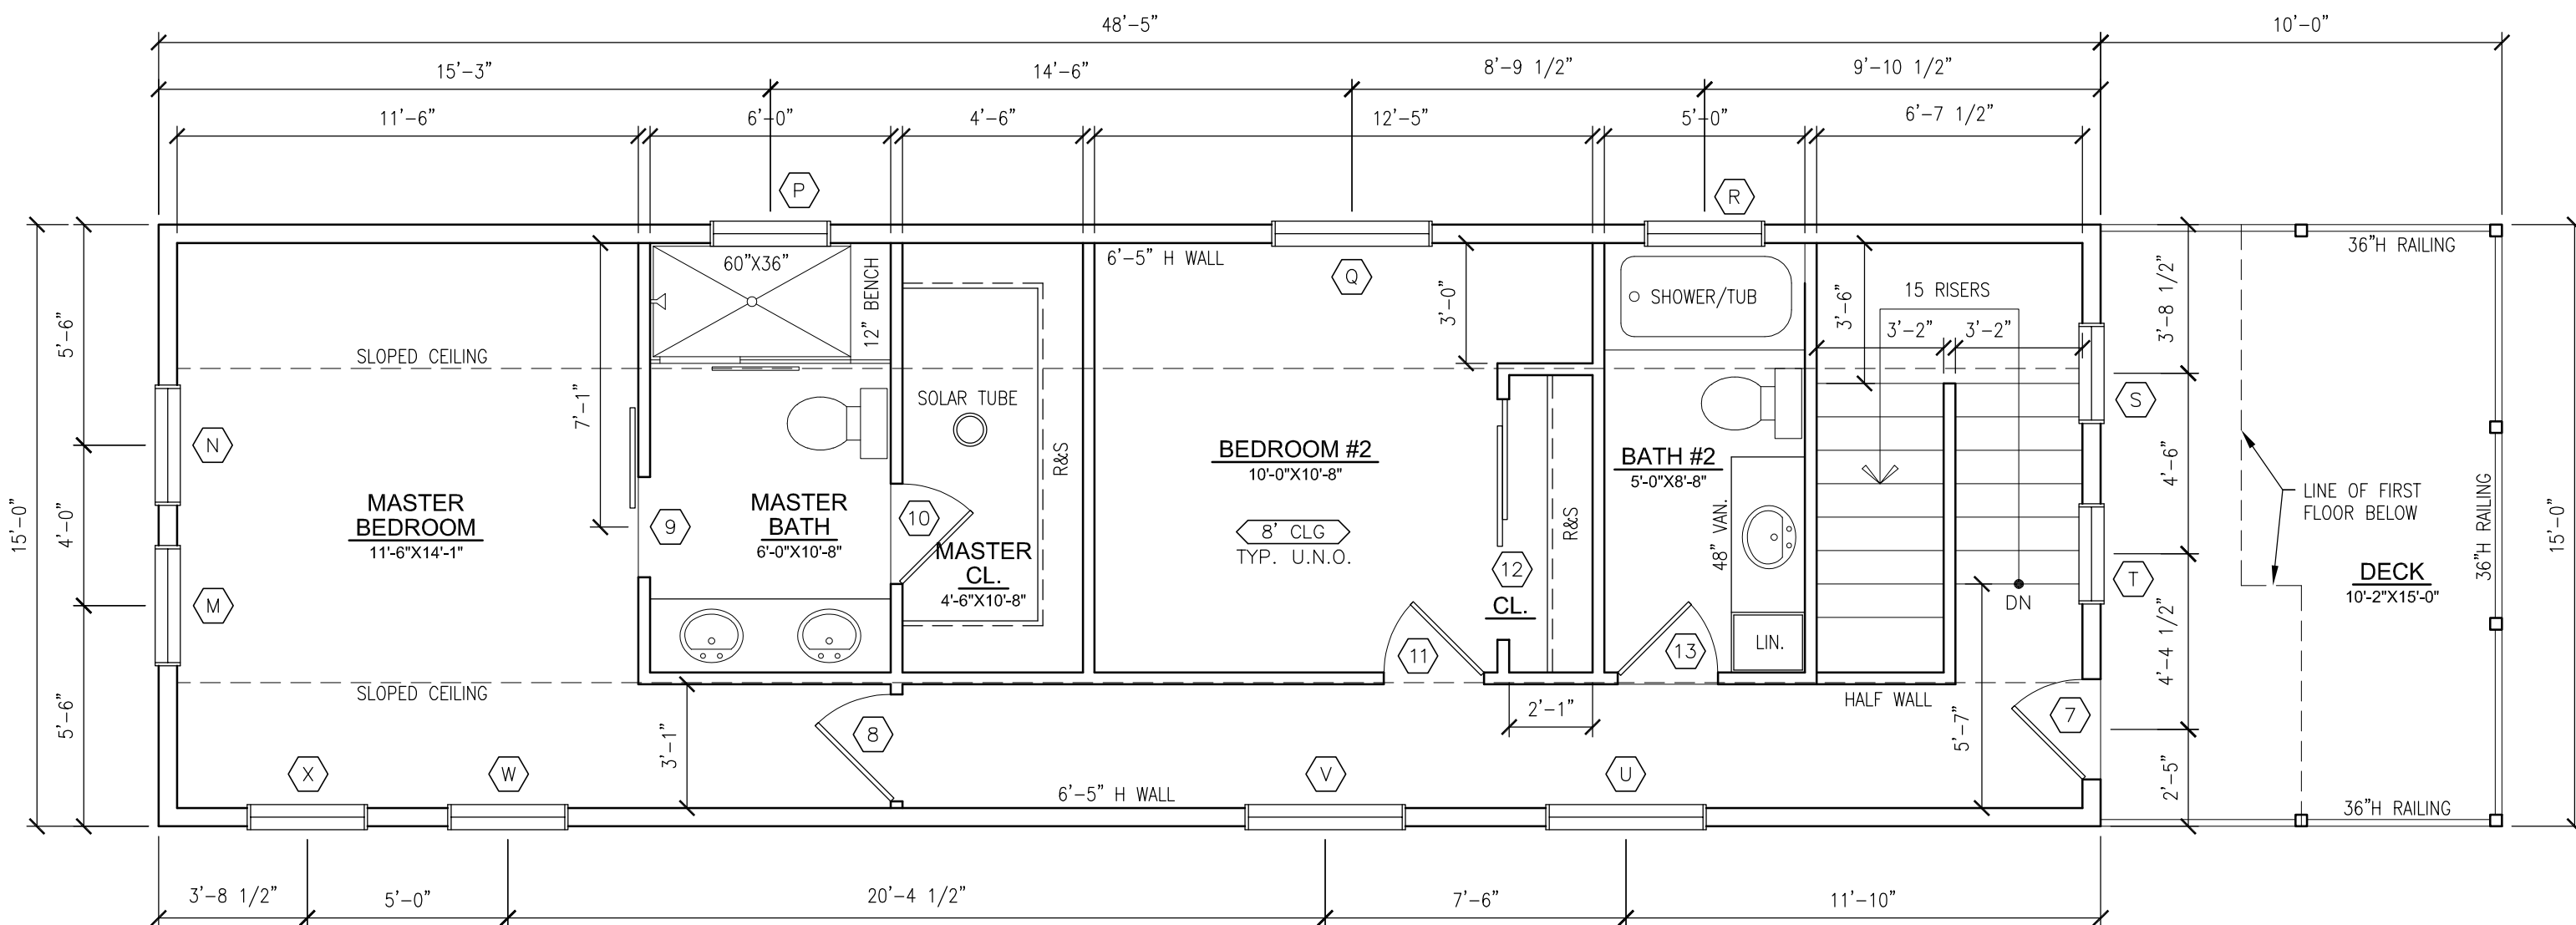

3 SECOND FLOOR CONSTRUCTION PLAN
A1.0 SCALE: 1/4"=1'-0"

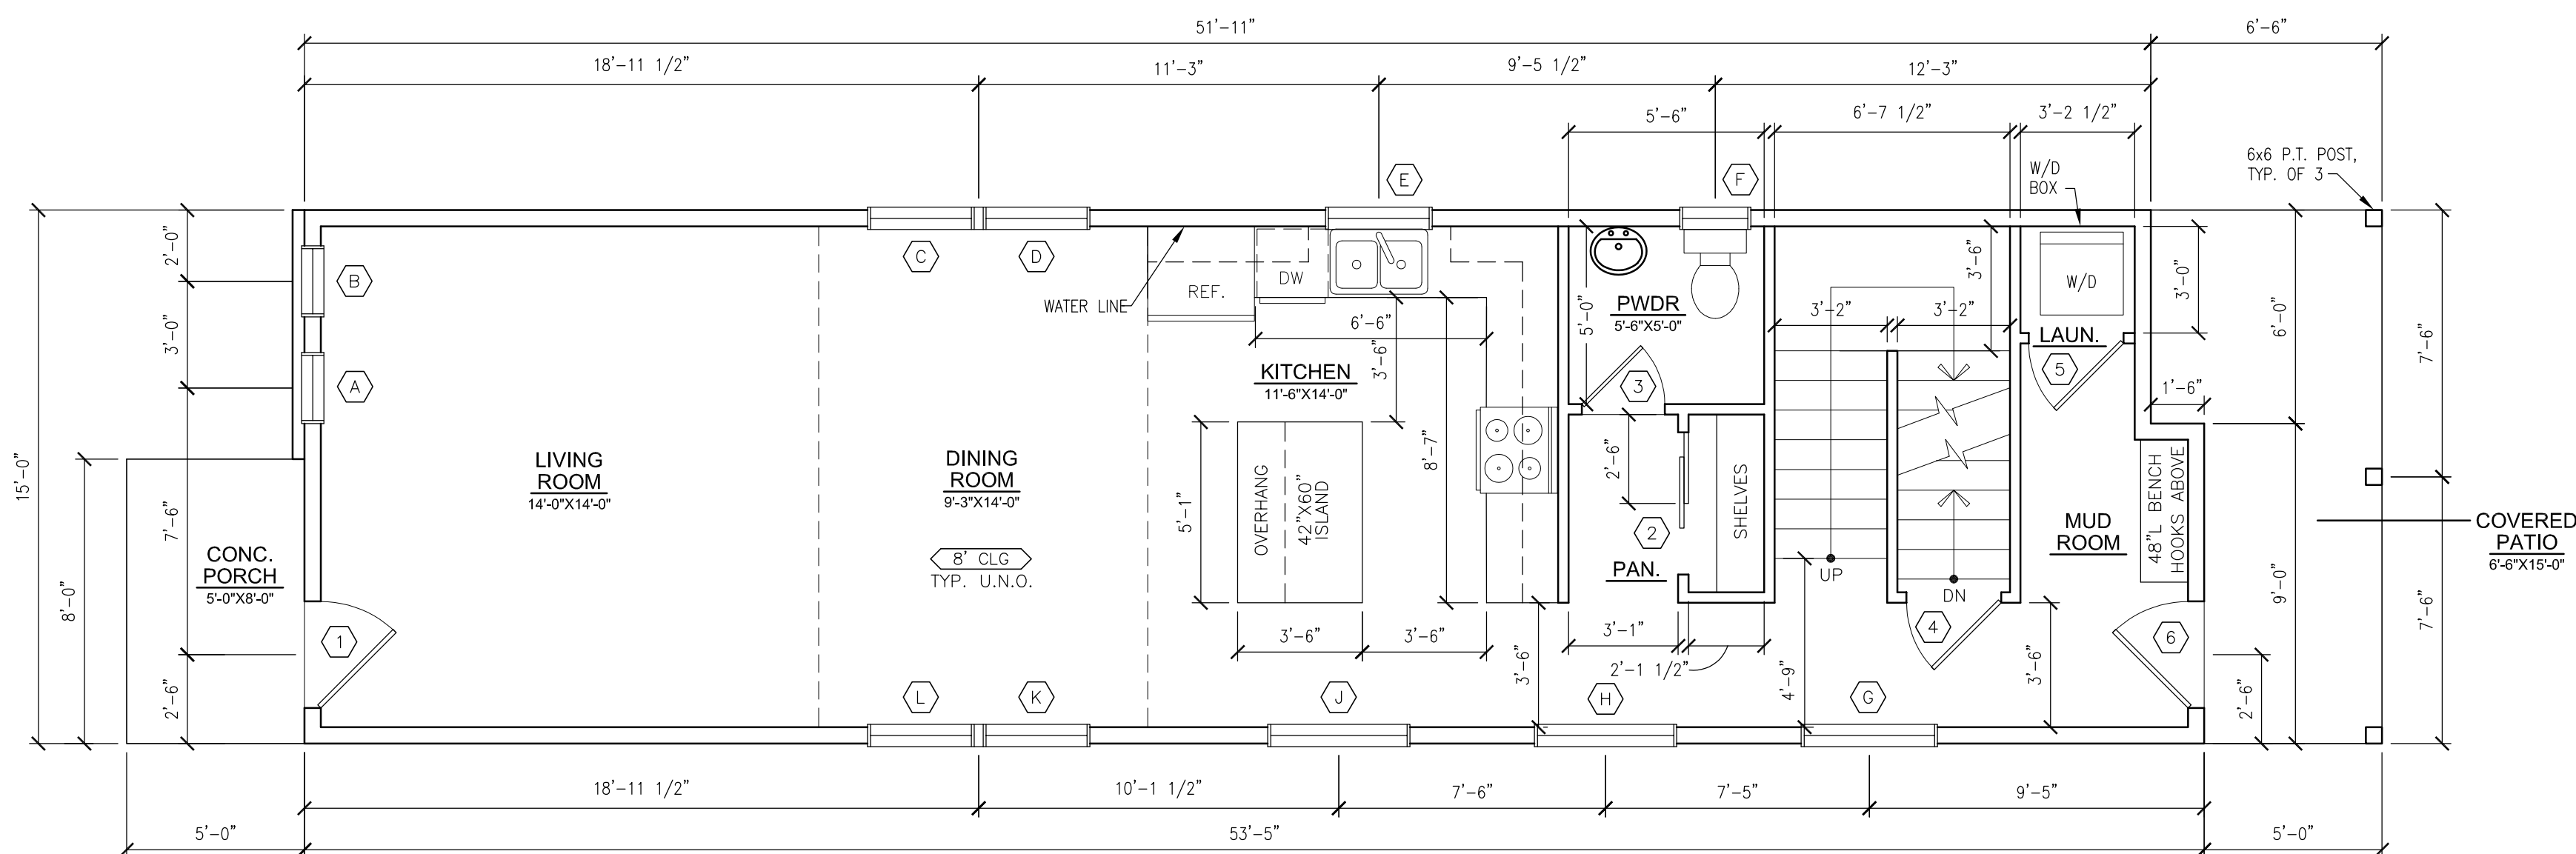


2 FIRST FLOOR CONSTRUCTION PLAN
A1.0 SCALE: 1/4"=1'-0"

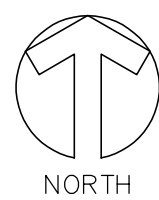

FIRST FLOOR - 792 SQ. FT.
SECOND FLOOR - 651 SQ. FT.
TOTAL: 1,443 SQ. FT.

BASEMENT FINISHED - 466 SQ. FT.
TOTAL FINISHED - 2,042 SQ. FT.

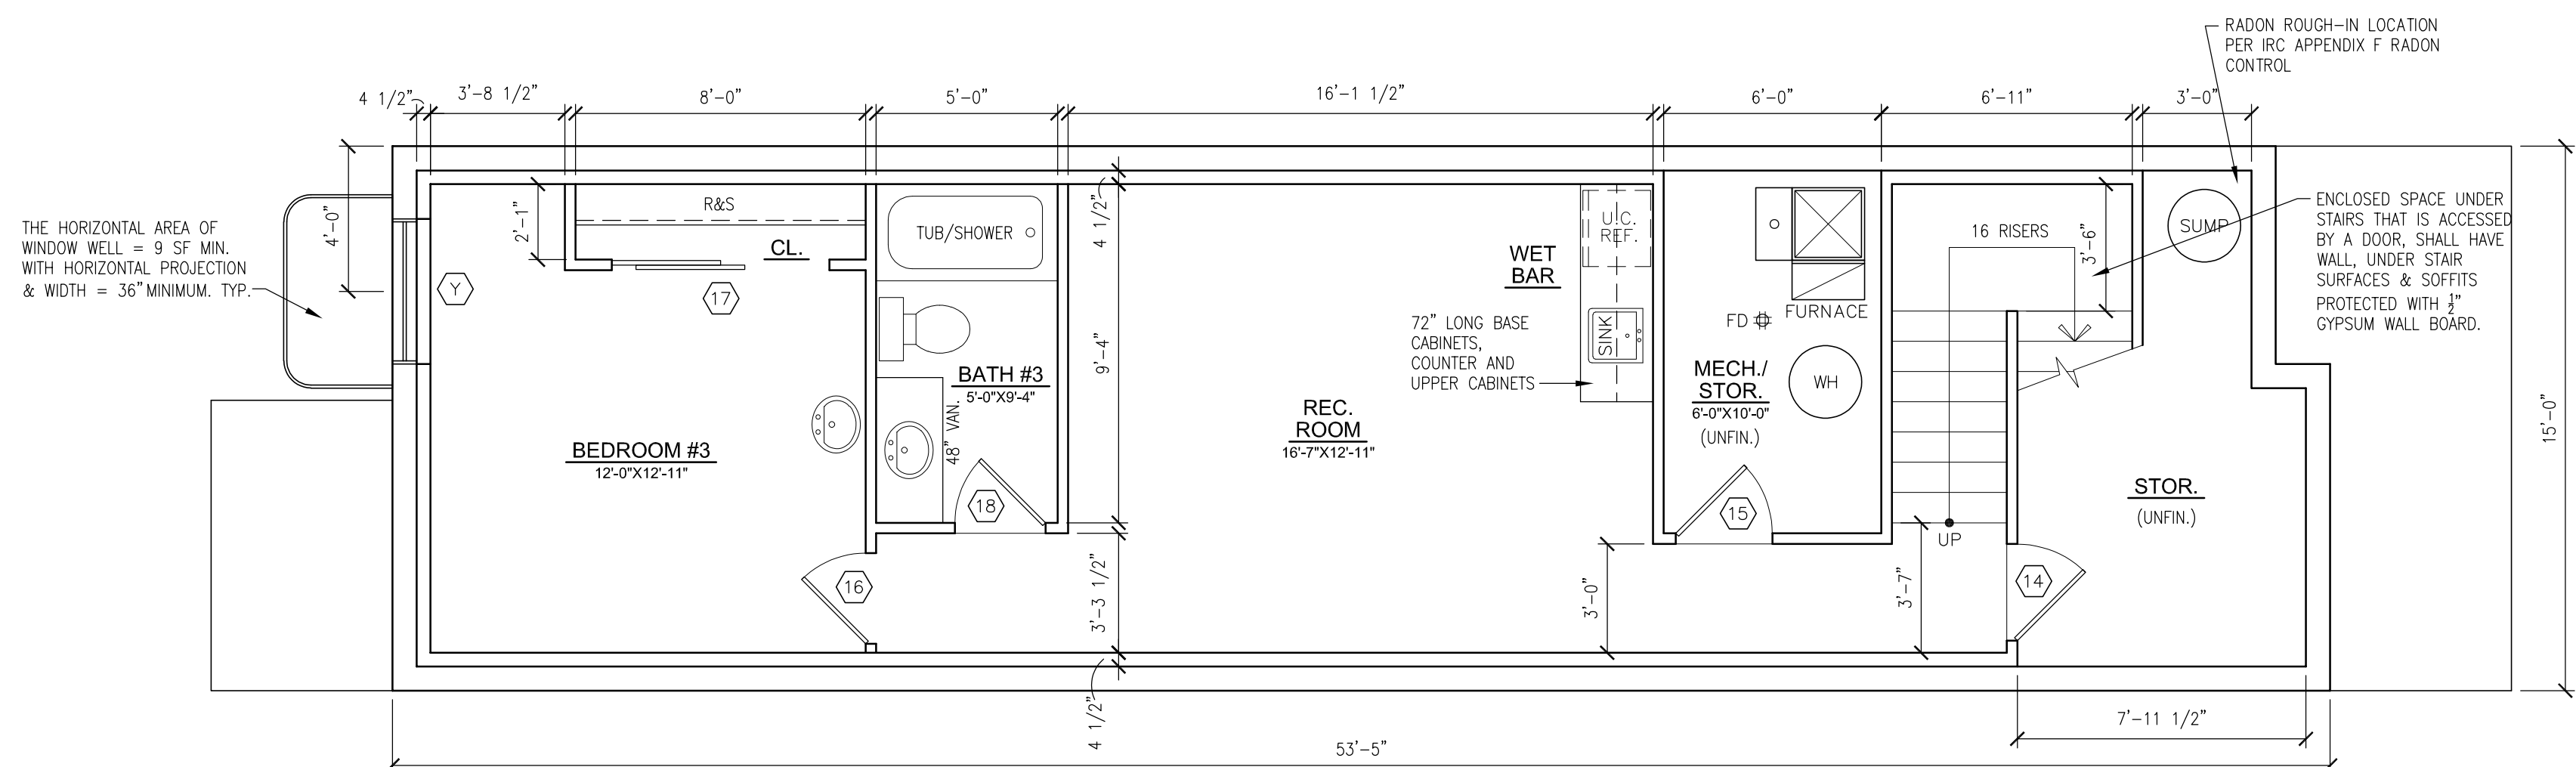


1 BASEMENT CONSTRUCTION PLAN
A1.0 SCALE: 1/4"=1'-0"




BASEMENT FINISHED - 466 SQ. FT.
BASEMENT UNFINISHED - 201 SQ. FT.

NOTES:
1) ALL DIMENSIONS ARE TO ROUGH FRAMING.
2) ALL EXTERIOR WALLS TO BE 2X6 WALLS.
3) INTERIOR WALLS TO BE 2X4 U.N.O.

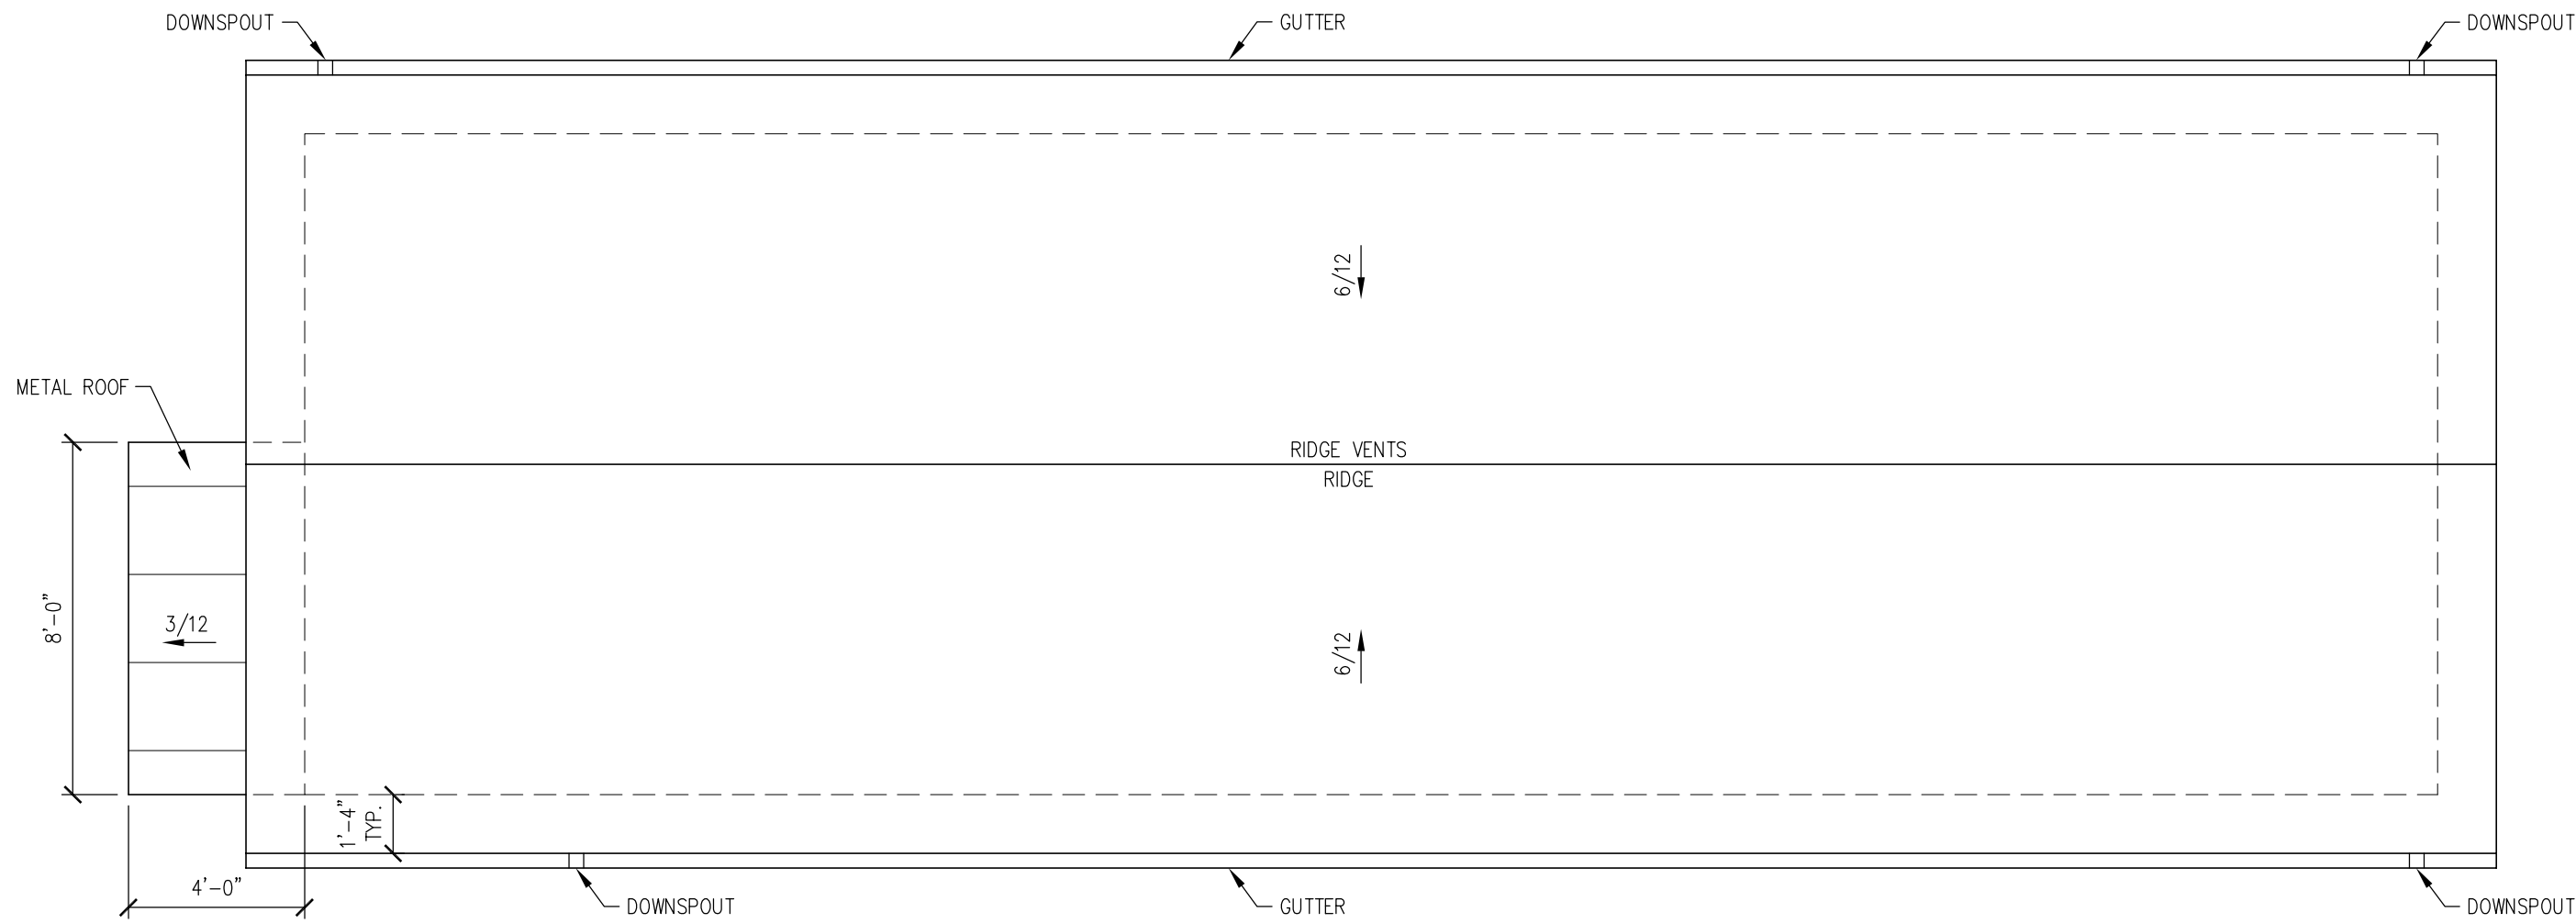

1 ROOF PLAN
A1.2 SCALE: 1/4"=1'-0"

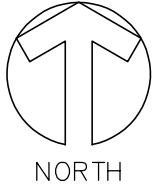

WINDOW SCHEDULE					
ID	SIZE	TYPE	HDR HT.	SILL HT.	NOTES
A	24"W X 48"H	FIXED	90"	42"	TEMPERED / MULLED
	24"W X 18"H	AWNING	39"	21"	
B	24"W X 48"H	FIXED	90"	42"	TEMPERED / MULLED
	24"W X 18"H	AWNING	39"	21"	
C	36"W X 60"H	SINGLE HUNG	90"	30"	MULLED
D	36"W X 60"H	SINGLE HUNG	90"	30"	
E	36"W X 48"H	SINGLE HUNG	90"	42"	
F	24"W X 48"H	SINGLE HUNG	90"	42"	OBSCURE
G	48"W X 60"H	SINGLE HUNG	90"	30"	
H	48"W X 60"H	SINGLE HUNG	90"	30"	
J	48"W X 60"H	SINGLE HUNG	90"	30"	
K	36"W X 60"H	SINGLE HUNG	90"	30"	MULLED
L	36"W X 60"H	SINGLE HUNG	90"	30"	
M	30"W X 60"H	CASEMENT	84"	24"	
N	30"W X 60"H	CASEMENT	84"	24"	
P	36"W X 18"H	FIXED	69"	57"	TEMPERED
Q	48"W X 48"H	SINGLE HUNG	69"	21"	
R	36"W X 18"H	FIXED	69"	57"	TEMPERED
S	24"W X 24"H	FIXED	80"	56"	TEMPERED
T	24"W X 24"H	FIXED	80"	56"	TEMPERED
U	48"W X 48"H	SINGLE HUNG	78"	30"	
V	48"W X 48"H	SINGLE HUNG	78"	30"	
W	36"W X 12"H	FIXED	69"	57"	
X	36"W X 12"H	FIXED	69"	57"	
Y	48"W X 48"H	SLIDER	84"	36"	EGRESS W/ WINDOW WELL AND LADDER
WINDOWS NEED TO MEET MIN. 0.30 U-FACTOR AND 0.40 SHGC OR BETTER					

DOOR SCHEDULE							
ID	SIZE	TYPE	S/D	HAND	MATERIAL	HARDWARE	NOTES
1	36"W X 80"H	ENTRY	SINGLE	RH	STEEL	KEYED ENTRY	
2	48"W X 80"H	2-PANEL BIPASS	DOUBLE		COMPOSITE	PASSAGE	
3	28"W X 80"H	2-PANEL	SINGLE	LH	COMPOSITE	PRIVACY	
4	32"W X 80"H	2-PANEL	SINGLE	LH	COMPOSITE	PASSAGE	
5	32"W X 80"H	2-PANEL	SINGLE	LH	COMPOSITE	PASSAGE	
6	36"W X 80"H	FULL LITE	SINGLE	LH	STEEL	KEYED ENTRY	TEMPERED
7	30"W X 80"H	FULL LITE	SINGLE	LH	FIBERGLASS	PRIVACY	TEMPERED
8	32"W X 80"H	2-PANEL	SINGLE	LH	COMPOSITE	PRIVACY	
9	30"W X 80"H	BARN DOOR	SINGLE		COMPOSITE	PRIVACY	
10	30"W X 80"H	2-PANEL	SINGLE	RH	COMPOSITE	PASSAGE	
11	30"W X 80"H	2-PANEL	SINGLE	RH	COMPOSITE	PRIVACY	
12	72"W X 80"H	2-PANEL BIPASS	DOUBLE		COMPOSITE	PASSAGE	
13	30"W X 80"H	2-PANEL	SINGLE	LH	COMPOSITE	PRIVACY	
14	32"W X 80"H	2-PANEL	SINGLE	RH	COMPOSITE	PASSAGE	
15	32"W X 80"H	2-PANEL	SINGLE	LH	COMPOSITE	PASSAGE	
16	30"W X 80"H	2-PANEL	SINGLE	LH	COMPOSITE	PRIVACY	
17	72"W X 80"H	2-PANEL BIPASS	DOUBLE		COMPOSITE	PASSAGE	
18	30"W X 80"H	2-PANEL	SINGLE	RH	COMPOSITE	PRIVACY	

ROOF NOTES:

- ROOF VENTING REQUIREMENTS:
THE MINIMUM NET FREE VENTILATING AREA SHALL BE 1/150 OF THE AREA OF THE VENTED SPACE.
BLDG. AREA/150 = 792/150 = 5.28 S.F. VENT AREA (760 SQ. IN.)

EXCEPTION: THE MINIMUM NET FREE VENTILATION AREA SHALL BE 1/300 OF THE VENTED SPACE PROVIDED NOT LESS THAN 40 PERCENT AND NOT MORE THAN 50 PERCENT OF THE REQUIRED VENTILATING AREA IS PROVIDED BY VENTILATORS LOCATED IN THE UPPER PORTION OF THE ATTIC OR RAFTER SPACE. UPPER VENTILATORS SHALL BE LOCATED NOT MORE THAN 3 FT BELOW THE RIDGE OR HIGHEST POINT OF THE SPACE, MEASURED VERTICALLY WITH THE BALANCE OF THE REQUIRED VENTILATION PROVIDED BY EAVE OR CORNICE VENTS. WHERE THE LOCATION OF WALL OR ROOF FRAMING MEMBERS CONFLICTS WITH THE INSTALLATION OF UPPER VENTILATORS, INSTALLATION MORE THAN 3 FT BELOW THE RIDGE OR HIGHEST POINT OF THE SPACE SHALL BE PERMITTED.

- ROOF ASSEMBLIES MUST COMPLY WITH CHAPTER 9, IRC.
- ROOF VENTILATION: ENCLOSED ATTICS AND ENCLOSED RAFTER SPACES FORMED WHERE CEILINGS ARE APPLIED DIRECTLY TO THE UNDERSIDE OF ROOF RAFTERS MUST HAVE CROSS VENTILATION FOR EACH SEPARATE SPACE BY VENTILATING OPENINGS PROTECTED AGAINST THE ENTRANCE OF RAIN OR SNOW. THE TOTAL NEW FREE VENTILATING AREA MUST NOT BE LESS THAN 1 TO 150 OF THE AREA OF THE SPACE VENTILATED EXCEPT THAT THE TOTAL AREA IS PERMITTED TO BE REDUCED TO 1 TO 300 PROVIDED AT LEAST 40% AND NOT MORE THAN 50% OF THE REQUIRED VENTILATING AREA IS PROVIDED BY VENTILATORS LOCATED IN THE UPPER PORTION OF THE ATTIC OR RAFTER SPACE. UPPER VENTILATORS MUST BE LOCATED NOT MORE THAN 3 FEET BELOW THE RIDGE OR HIGHEST POINT OF THE SPACE MUST BE PERMITTED. SECTION R806, IRC.

- WHEN THERE IS USABLE SPACE ABOVE AND BELOW THE CONCEALED SPACE OF A FLOOR-CEILING ASSEMBLY IN A SINGLE-FAMILY DWELLING, DRAFT STOPS MUST BE INSTALLED SO THAT THE AREA OF THE CONCEALED SPACE DOES NOT EXCEED 1000 S.F. PER SECTION R502.12, IRC.

- WHERE RAFTERS AND CEILING JOISTS COMBINE TO FORM A DEPTH TO THICKNESS RATIO OF AT LEAST 3:1, THE ENDS MUST BE HELD IN POSITION BY SOLID BLOCKING. ALL TRUSSES MUST BE SUPPORTED Laterally AT POINTS OF BEARING BY SOLID BLOCKING.

- FIRE BLOCKS ARE REQUIRED WITHIN STUD WALLS AT 10' INTERVALS AND AT THE FLOOR AND CEILING. FIRE BLOCKS ARE ALSO REQUIRED AT FLOOR AND CEILING PENETRATIONS AROUND VENTS, PIPES, DUCTS, ETC. THE INTERCONNECTIONS BETWEEN CONCEALED VERTICAL AND HORIZONTAL SPACES (SOFFITS), BETWEEN STAIRS STRINGERS, AND THE OPENINGS BETWEEN CHIMNEY CHASES AND ATTIC SPACES MUST BE FIRE STOPPED. FIRE BLOCKS MUST BE PROVIDED WITHIN UNFILLED SLEEPER-TYPE FLOOR SYSTEMS SO THAT NO AREA EXCEEDS 1000 S.F. FIRE BLOCK MATERIAL MAY BE 2" NOMINAL LUMBER GYP BOARD, ETC. SECURELY FASTENED IN PLACE. LOOSE-FILL INSULATION IS NOT ACCEPTABLE.

- UNDERLAYMENT TO BE ONE LAYER OF 30# FELT OR (2) LAYERS OF 15# FELT.

- ICE BARRIER: 2 LAYERS OF SELF ADHERED SHEETS MUST BE INSTALLED AT ALL EAVES AND EXTEND FROM THE LOWEST EDGES OF ROOF SURFACES TO A POINT AT LEAST 24" INSIDE THE EXTERIOR WALL LINE OF THE BUILDING PER R905.

- ALL SHEET METAL ROOF PENETRATIONS TO BE PAINTED TO MATCH COLOR OF MOST ADJACENT ROOFING.

- ALL VALLEYS TO HAVE CONTINUOUS SHEET METAL / SELF ADHERED FLASHING OR EQUAL. THEY MUST BE A CLOSED TYPE INSTALLATION.

- DISCHARGE DOWNSPOUTS A MINIMUM OF 5' AWAY FROM FOUNDATION.

- ALL ROOF PENETRATIONS MUST BE COMPLETED PRIOR TO ROOF INSTALLATION & SEALED WATERTIGHT.

- COORDINATE LOCATIONS OF ALL VENTS AND EXHAUST OPENING NOT TO BE LOCATED IN VALLEYS OR ON RIDGES.

- ALL ROOF FLASHING, GUTTERS & DOWNSPOUTS MUST BE 24 GA. PREFINISHED METAL, IN COLORS AS SELECTED BY OWNER.

- INSTALL GUTTERS AND DOWNSPOUTS PER COUNTY REQUIREMENTS.

- INSTALL DOUBLE UNDERLAYMENT AT ALL ROOFS UNDER 4:12 PITCH.



STAMP

CONSULTANT

CROSS RESIDENCE
2568 EATON STREET
EDGEWATER, CO 80214

FEB. 2, 2025				
DRAWING SET DATE				
Issues/Revisions	1	= Issue		
	Δ	= Revision		
NO.	DATE	PURPOSE	BY	CHK

Proj. #:	
Scale:	1/4"=1'-0"
File:	
Sheet Title	ROOF PLAN
Sheet No.	of
A1.2	

STAMP

CONSULTANT

CROSS RESIDENCE
2568 EATON STREET
EDGEWATER, CO 80214

FEB. 2, 2025

DRAWING SET DATE

Issues/Revisions 1 = Issue
△ = Revision

NO. DATE PURPOSE BY CHK

Proj. #:

Scale: 1/4"=1'-0"


File:

Sheet Title
ELEVATIONS


Sheet No.

of


A2.0

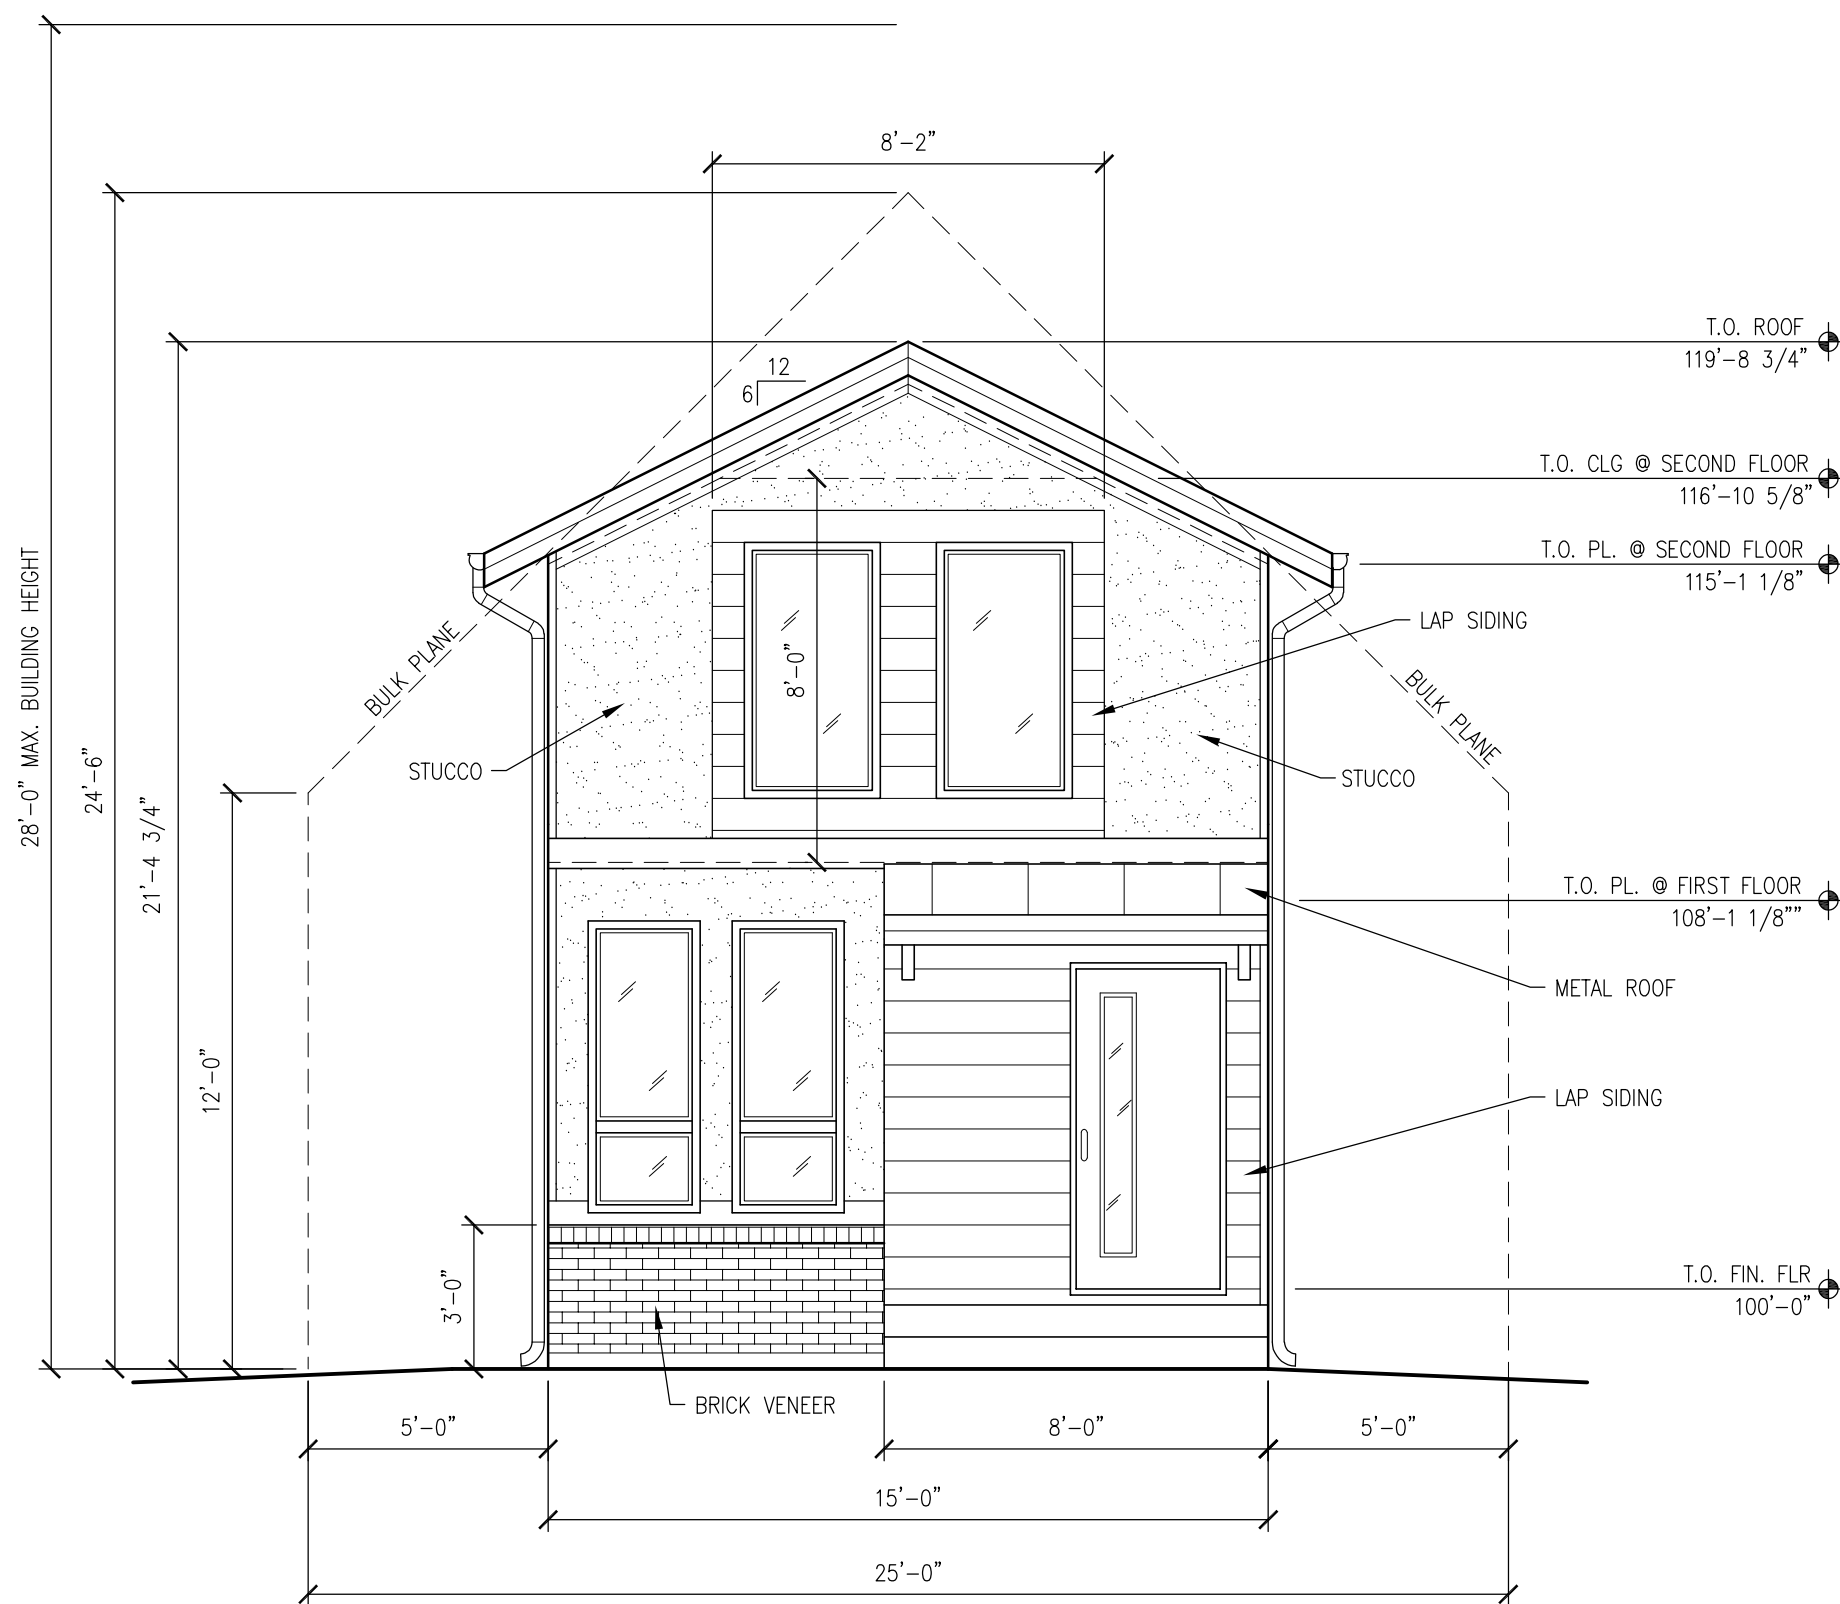


1 FRONT ELEVATION
A2.0 SCALE: 1/4"=1'-0"

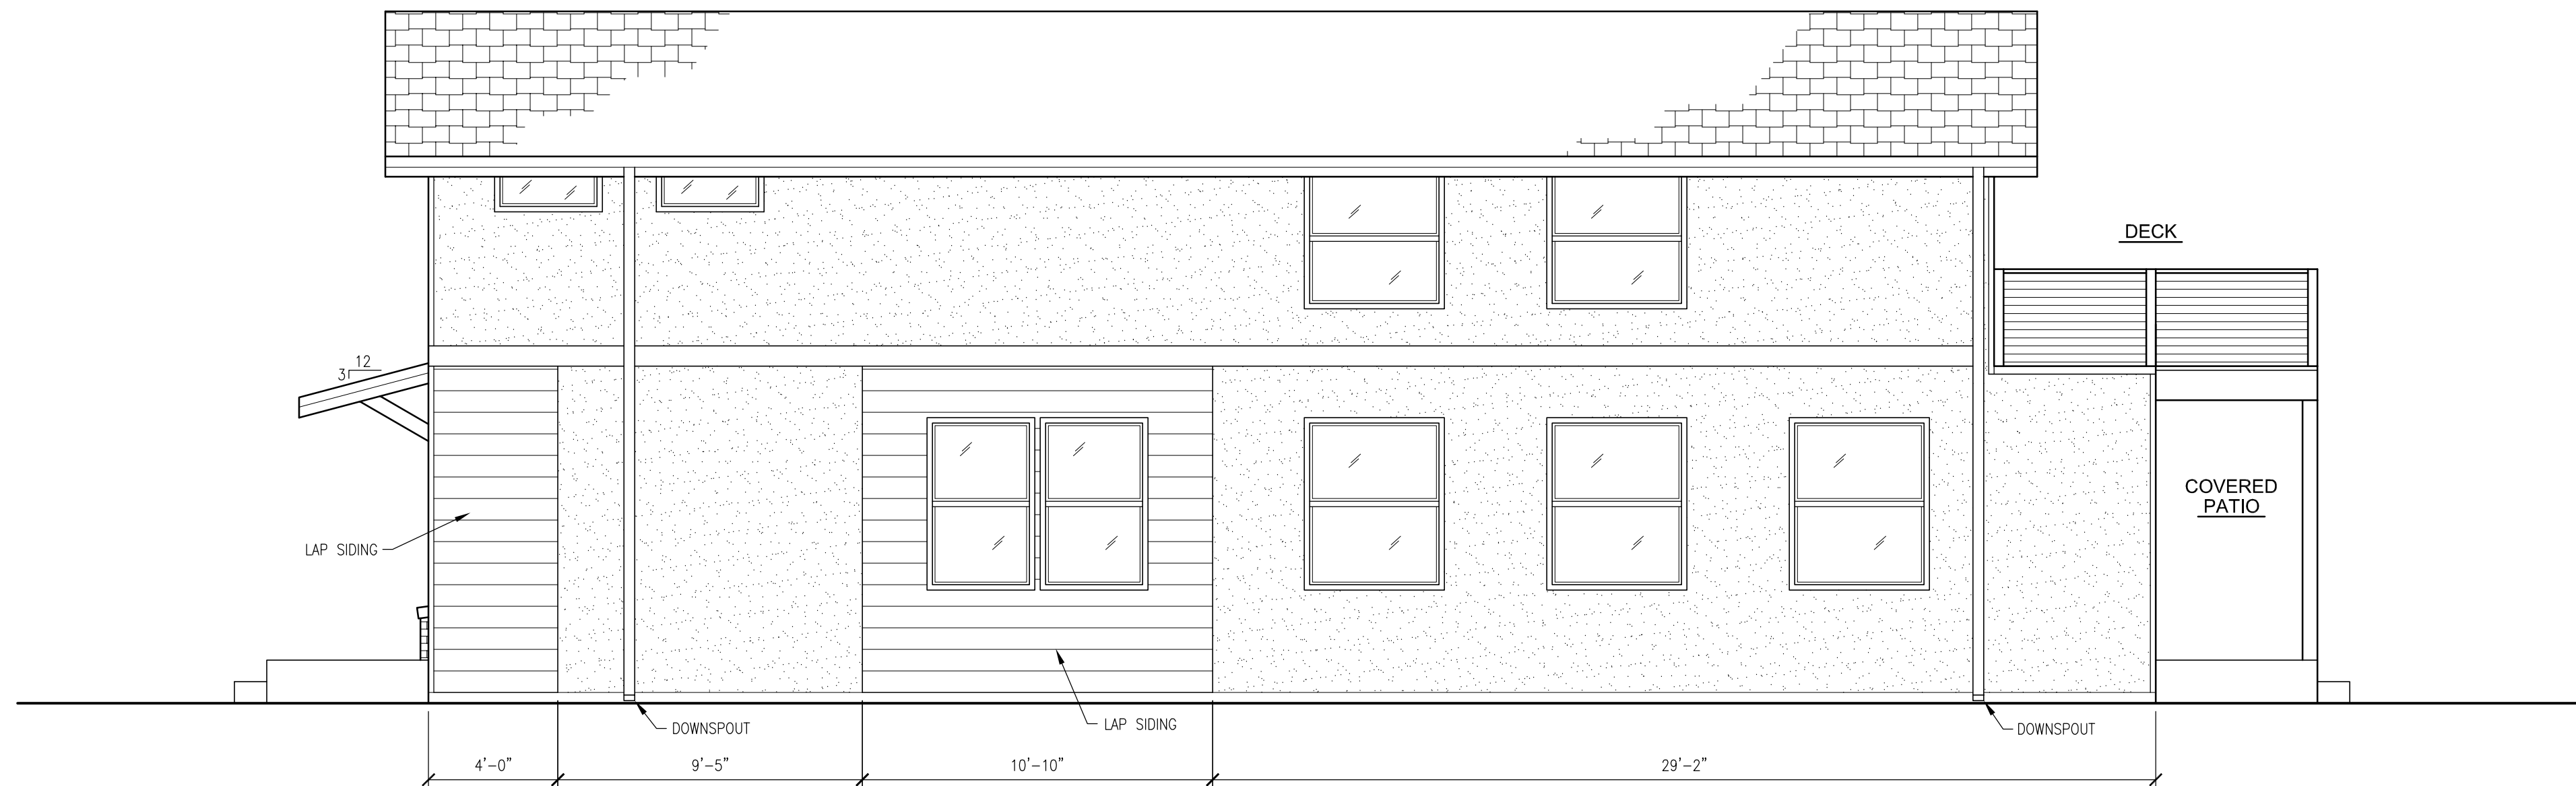


2 RIGHT SIDE ELEVATION
A2.0 SCALE: 1/4"=1'-0"

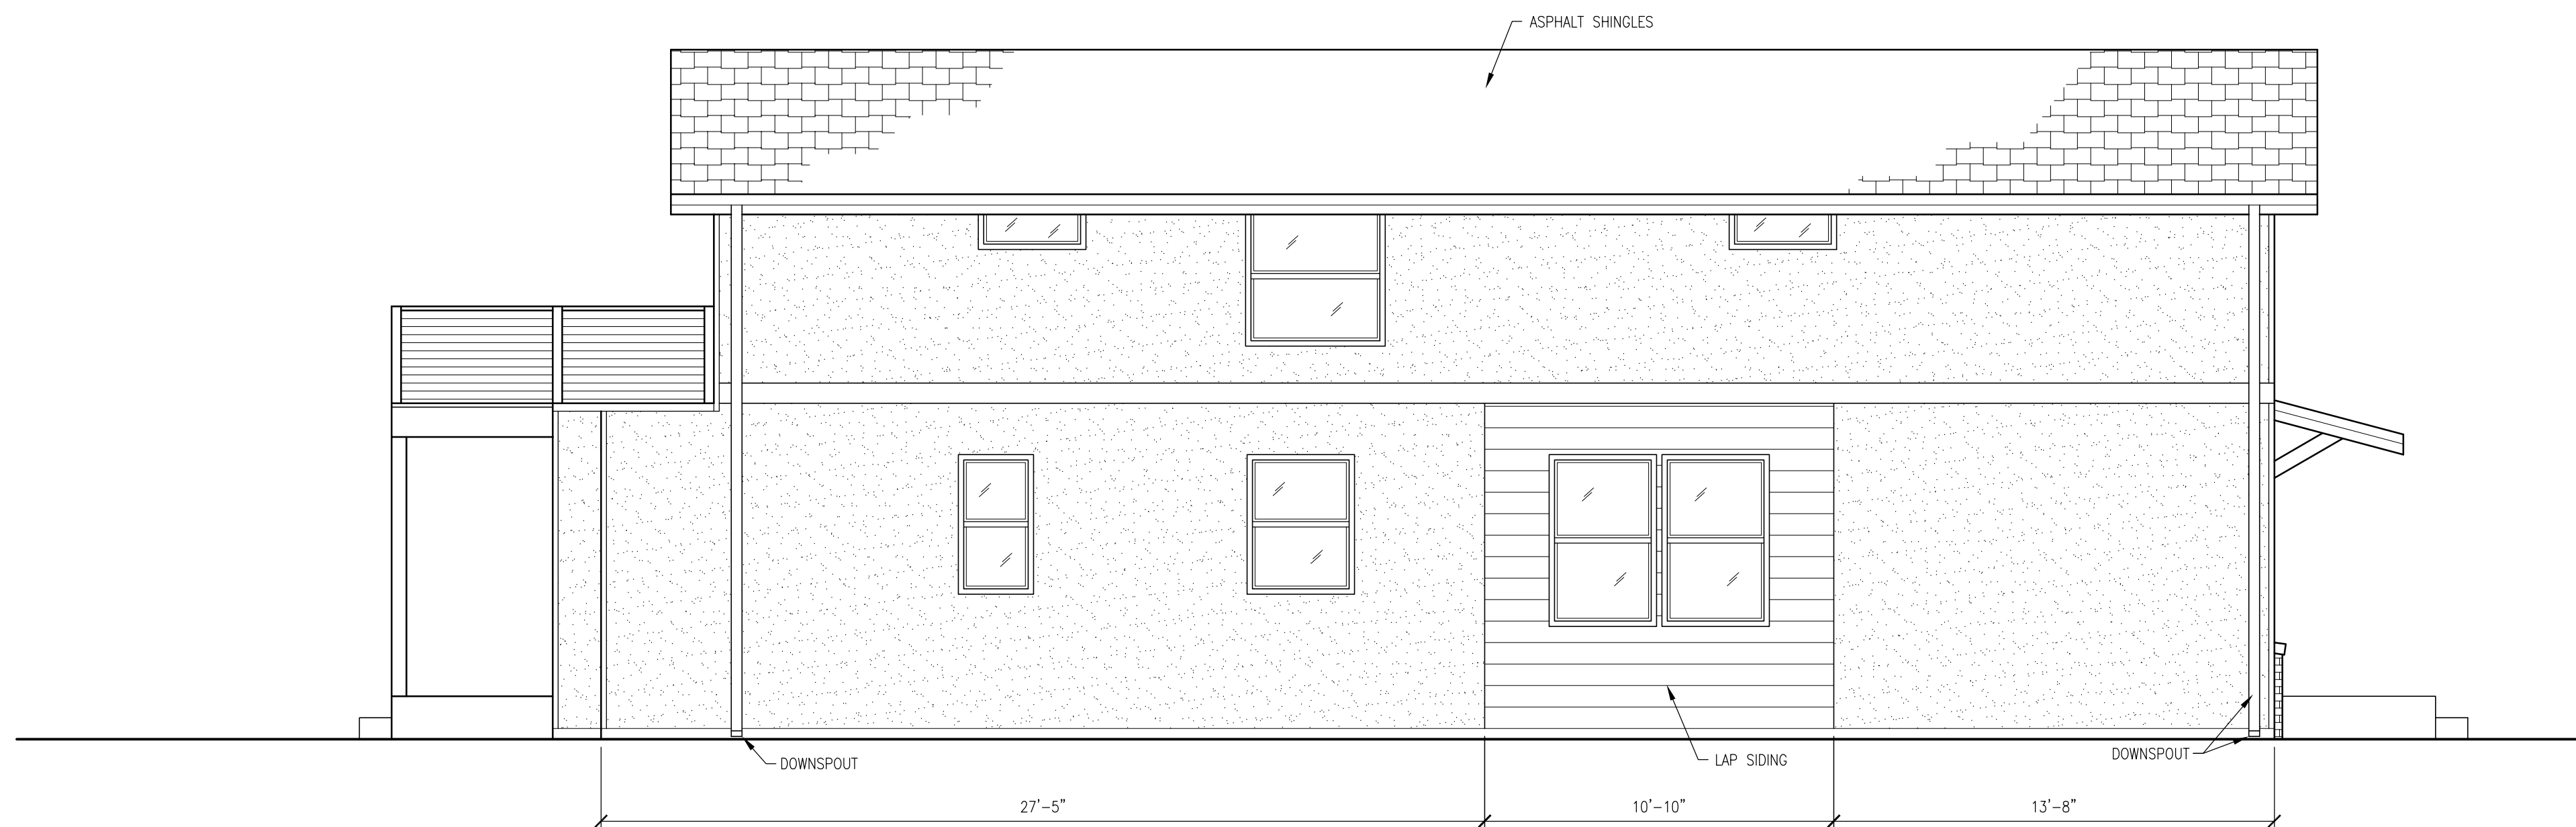

3 LEFT SIDE ELEVATION
A2.0 SCALE: 1/4"=1'-0"

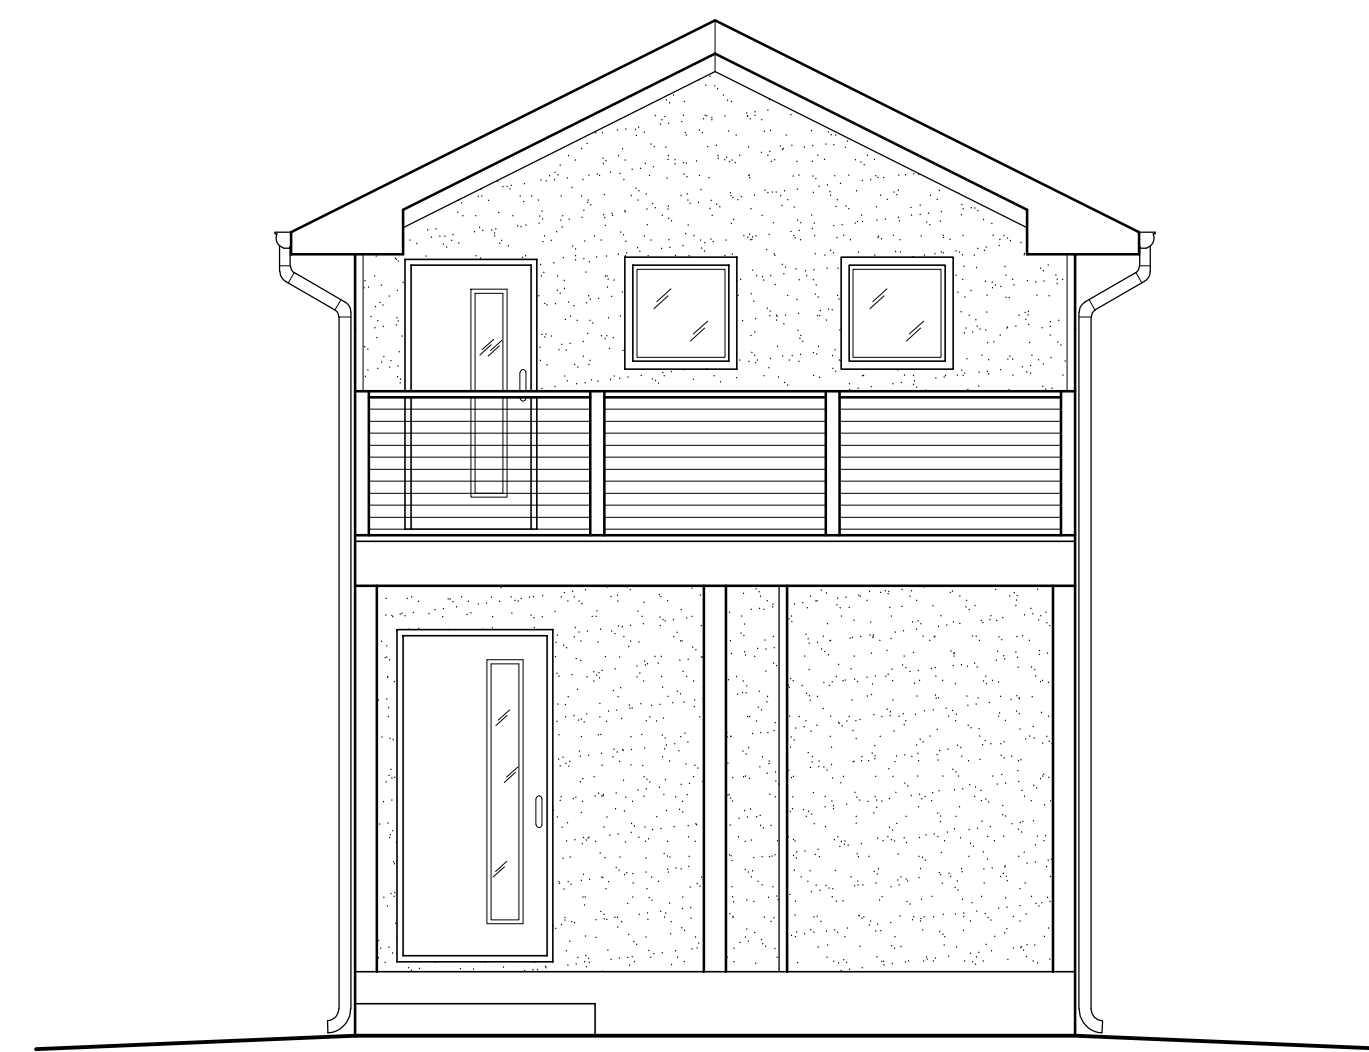

4 REAR ELEVATION
A2.0 SCALE: 1/4"=1'-0"

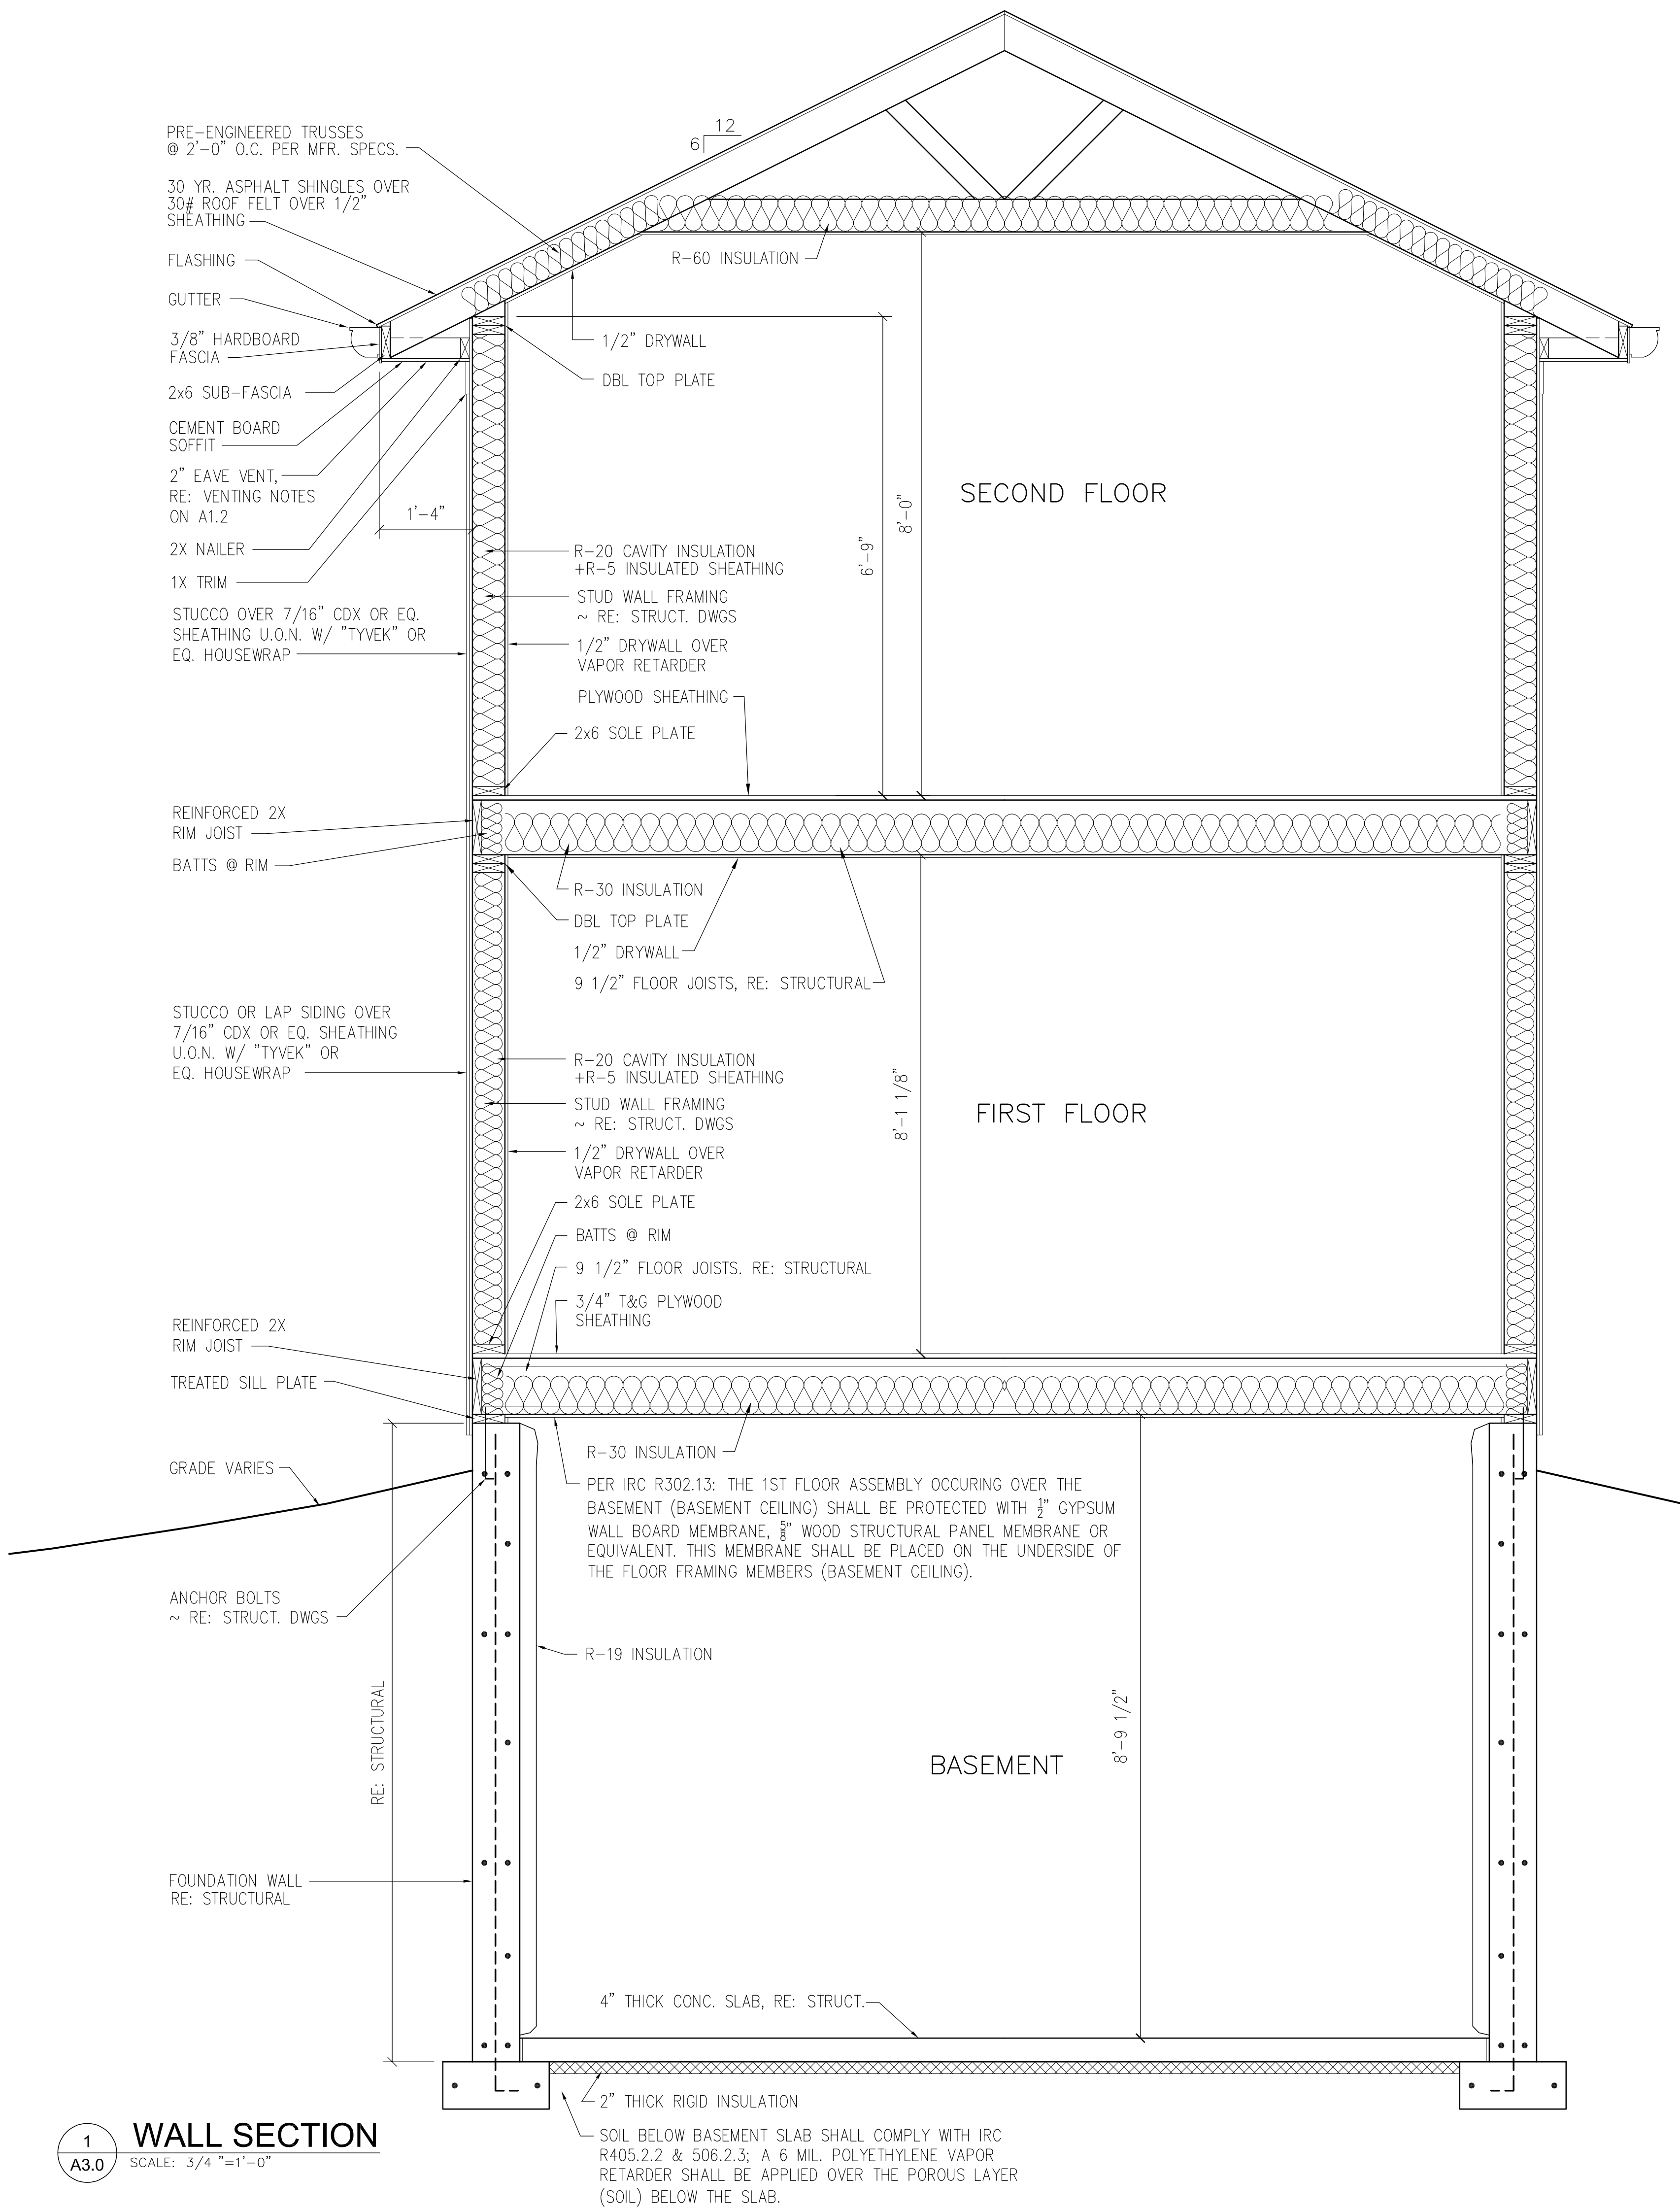

1
A3.0

WALL SECTION

SCALE: 3/4"=1'-0"

STAMP

CONSULTANT

CROSS RESIDENCE

2568 EATON STREET
EDGEWATER, CO 80214

FEB. 2, 2025

DRAWING SET DATE

Issues/Revisions 1 = Issue
Δ = Revision

NO. DATE PURPOSE BY CHK

Proj. #:


Scale: 3/4"=1'-0"

File:

Sheet Title
BUILDING SECTION

Sheet No. of

A3.0

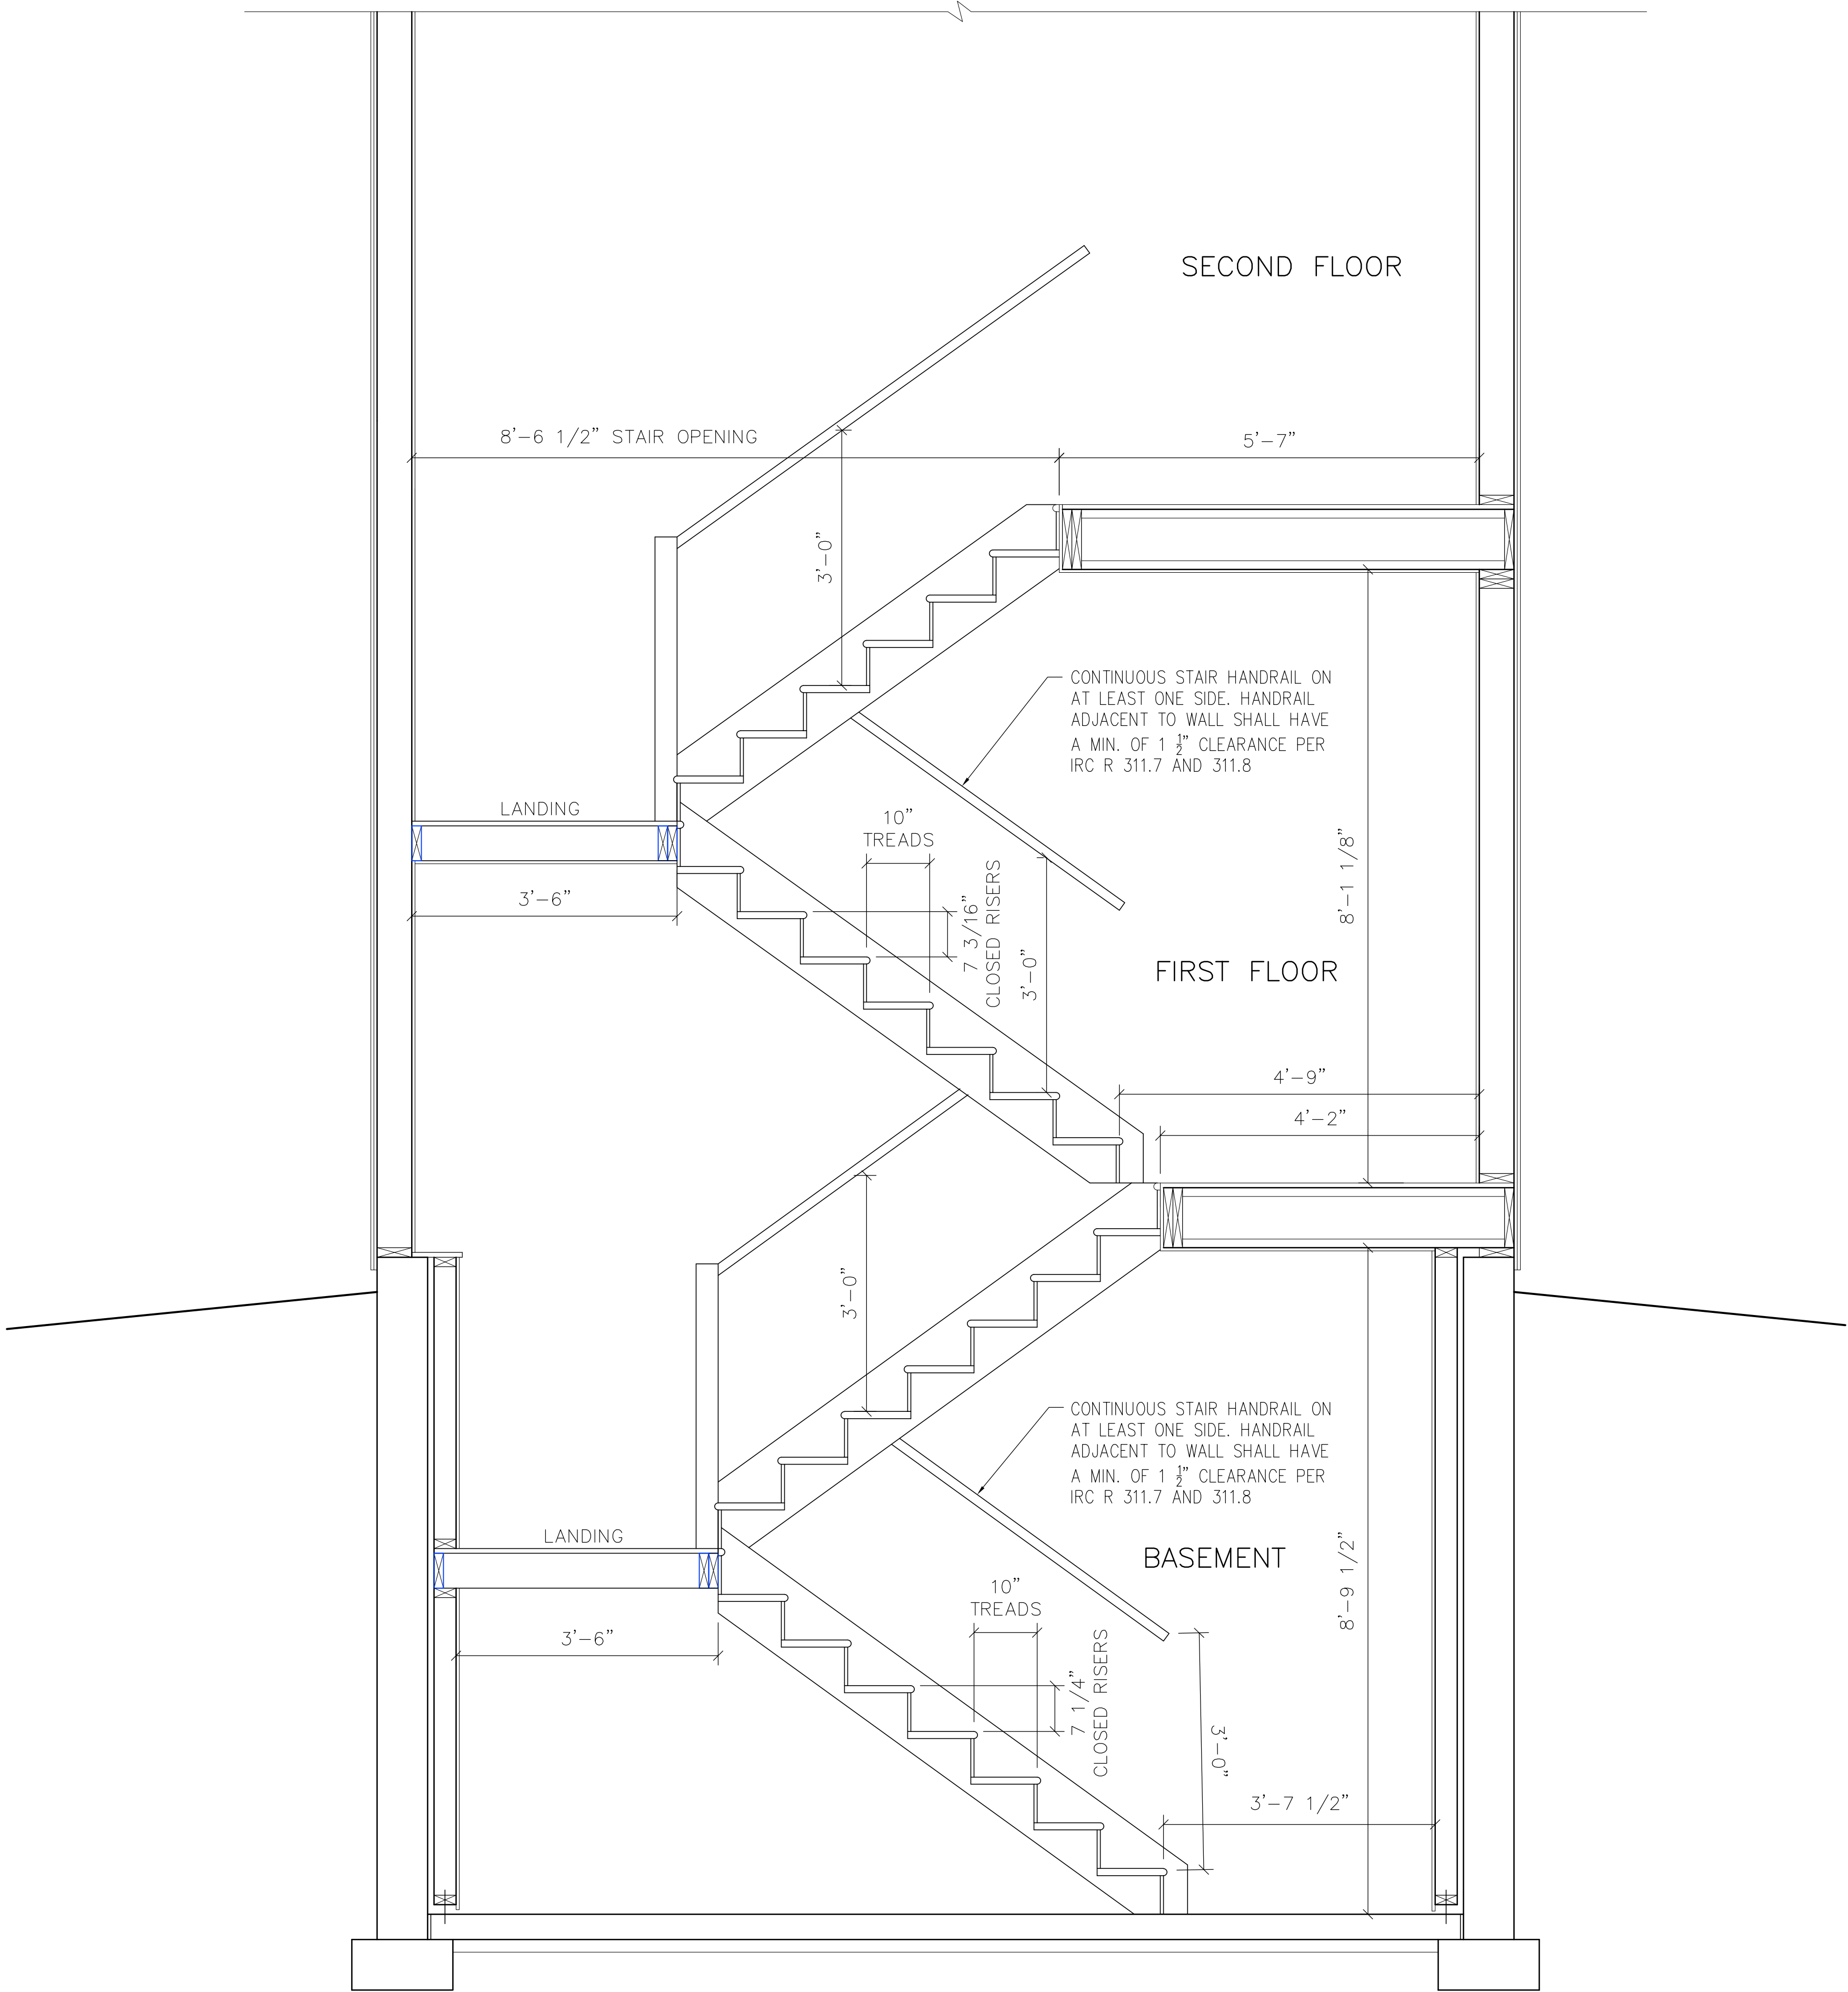

1
A3.1

STAIR SECTION

SCALE: 3/4"=1'-0"

STAMP

CONSULTANT

CROSS RESIDENCE
2568 EATON STREET
EDGEWATER, CO 80214

FEB. 2, 2025

DRAWING SET DATE

Issues/Revisions 1 = Issue
Δ = Revision

NO. DATE PURPOSE BY CHK

Proj. #:

Scale: 3/4"=1'-0"

File:

Sheet Title

STAIR SECTION

Sheet No.

of

A3.1

STAMP

CONSULTANT

CROSS RESIDENCE
2568 EATON STREET
EDGEWATER, CO 80214

FEB. 2, 2025
DRAWING SET DATE

Issues/Revisions 1 = Issue
Δ = Revision

NO.	DATE	PURPOSE	BY	CHK

Proj. #:

Scale: 1/4"=1'-0"


File:

Sheet Title
ELECTRICAL AND
LIGHTING PLANS

Sheet No.


of

E1.0


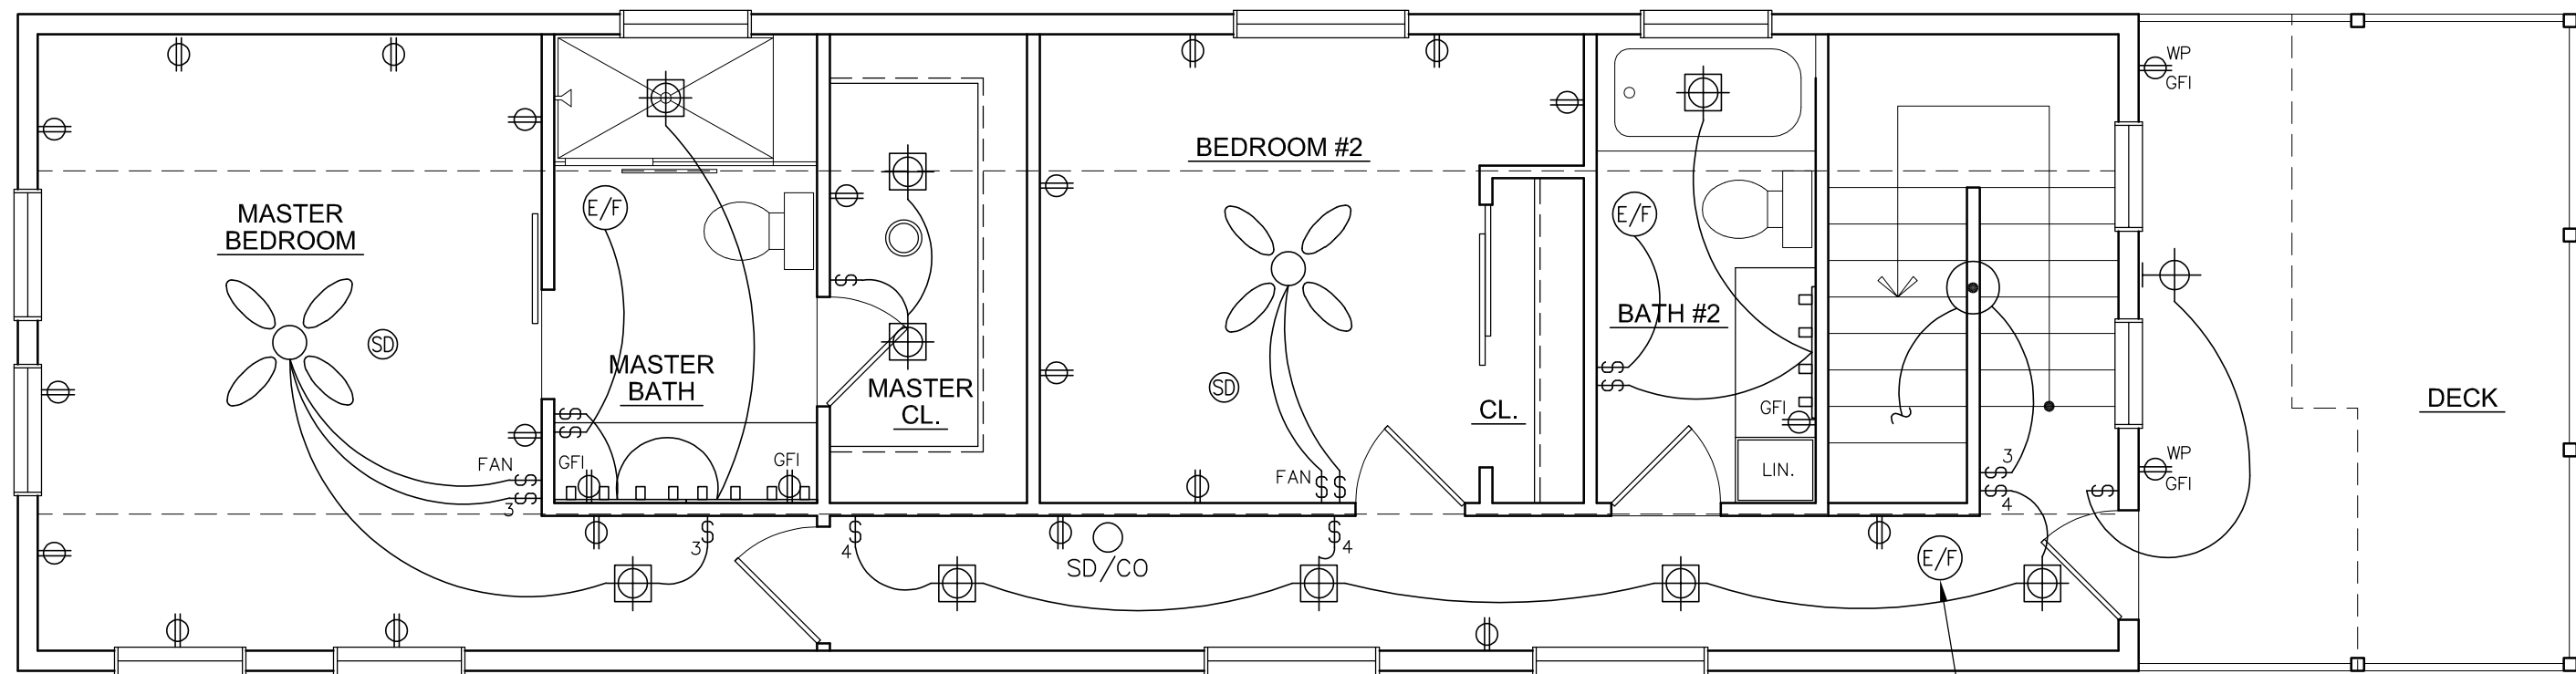


INSTALL WHOLE HOUSE MECH.
VENTILATION FAN WITH MIN.
90 cfm CONTINUOUS AIRFLOW

1
E1.0
SECOND FLOOR ELECTRICAL AND LIGHTING PLAN
SCALE: 1/4"=1'-0"

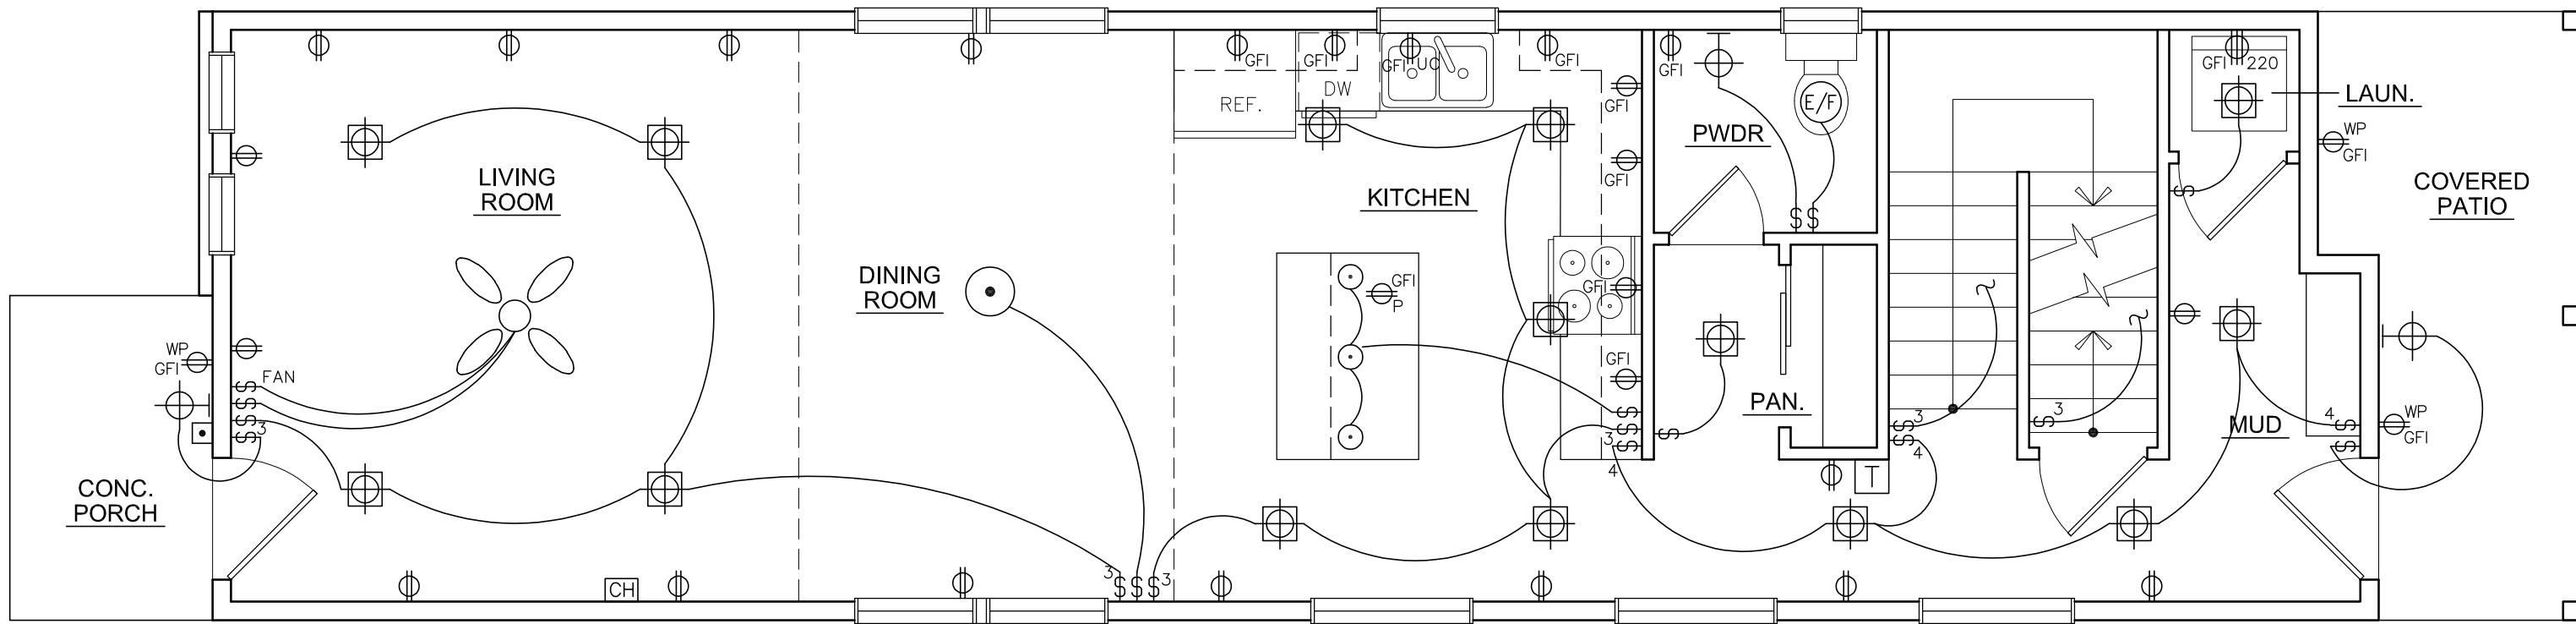

2
E1.0
FIRST FLOOR ELECTRICAL AND LIGHTING PLAN
SCALE: 1/4"=1'-0"

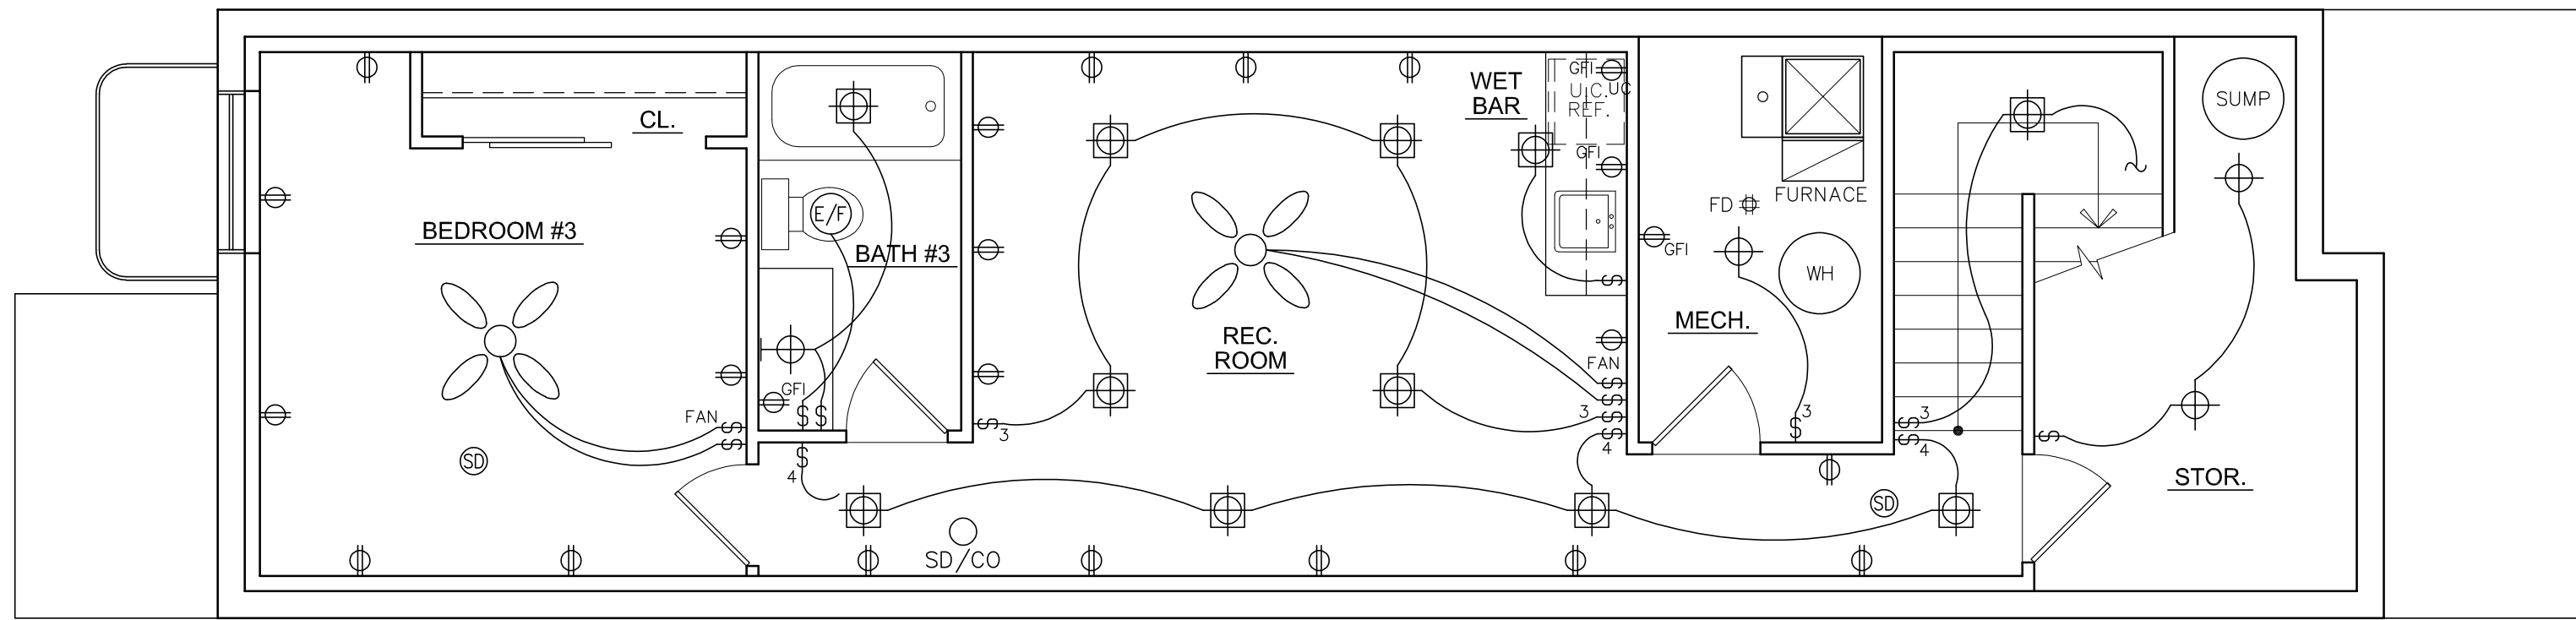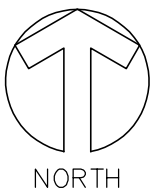

3
E1.0
BASEMENT ELECTRICAL AND LIGHTING PLAN
SCALE: 1/4"=1'-0"



ELECTRICAL NOTES:

1. PROVIDE SEPARATE CIRCUIT FOR BASEMENT FOR USE IN FUTURE CONSTRUCTION.
1. ALL SWITCHES TO BE MOUNTED AT 48" AFF (MAX).
2. ALL OUTLETS, U.N.O. TO BE MOUNTED AT 18" AFF.
3. LAYOUT SCHEMATIC ONLY—ACTUAL ELECTRICAL DESIGN BY OTHERS AND MUST COMPLY TO ALL LOCAL CODES.
4. PROVIDE SMOKE AND CO DETECTORS—TYP THROUGHOUT. DETECTORS TO BE HARD WIRED WITH BATTERY BACK-UP.
5. ALL HOT WATER PIPING TO BE THOROUGHLY INSULATED.
6. RECEPTACLE OUTLETS MUST BE INSTALLED IN HABITABLE ROOMS SO THAT NO POINT ALONG THE FLOOR LINE IN ANY WALL SPACE 2' OR MORE IN LENGTH IS MORE THAN 6', MEASURED HORIZONTALLY FROM AN OUTLET.
7. IN KITCHEN AND DINING AREAS, ELECTRICAL RECEPTACLES MUST BE INSTALLED AT EACH COUNTER SPACE WIDER THAT 12" SO THAT AT NO POINT ALONG THE WALL LINE IS MORE THAN 24" FROM AN OUTLET. PROVIDE AT LEAST ONE OUTLET AT ISLAND WITH TOP GREATER THAN 12".
8. PROVIDE GROUND FAULT PROTECTION AT THE FOLLOWING LOCATIONS:
 - BATHROOMS
 - EXTERIOR CONDITIONS
 - NON-DEDICATED GARAGE AND BASEMENT CONDITIONS
 - KITCHEN COUNTERTOP
 - WITHIN 6' OF WETBAR SINKSGFCI PROTECTION IS ALSO REQUIRED FOR ELECTRICAL EQUIPMENT IN WHIRLPOOL TYPE TUBS.
9. PROVIDE TWO OR MORE SMALL APPLIANCE BRANCH CIRCUITS FOR ALL RECEPTACLE OUTLETS IN KITCHEN, PANTRY, BREAKFAST ROOM, DINING ROOM OR SIMILAR AREAS. THESE CIRCUITS MUST SERVE NO MORE THAN THREE OUTLETS AND HAVE NO OTHER OUTLETS CONNECTED.
10. NO MORE THAN 8 ELECTRICAL OUTLETS MAY BE CONNECTED TO A 15 AMPRE BRANCH CIRCUIT (10 PER 20 AMPRE CIRCUIT).
11. LIGHT FIXTURE IN CLOTHES CLOSETS MUST COMPLY WITH LOCAL AND CURRENT ELECTRICAL CODES.
12. PROVIDE AN ELECTRICAL LIGHT IN ALL ATTIC AND CRAWL SPACES REQUIRING ACCESS FOR SERVICING OF EQUIPMENT. THE CONTROL SWITCH MUST BE LOCATED BY THE POINT OF ACCESS AND DUPLEX GFCI-PROTECTED ELECTRICAL SERVICE RECEPTACLE MUST BE PROVIDED AT OR NEAR THE EQUIPMENT.
13. THE GROUNDING ELECTRODE SYSTEM MUST INCLUDE AND ELECTRODE ENCASED BY AT LEAST 2" OD CONCRETE, LOCATED WITHIN AND NEAR THE BOTTOM OF A CONCRETE FOUNDATION OR FOOTING THAT IS IN DIRECT CONTACT WITH THE EARTH, CONSISTING OF AT LEAST 20' OF ONE OR MORE BARE OR ZINC GALVANIZED OR OTHER ELECTRONICALLY CONDUCTIVE COATED STEEL REINFORCING BARS OR RODS OF NOT LESS THAN 1/2" DIAMETER OR CONSISTING OF AT LEAST 20' OF BARE COPPER CONDUCTOR NOT SMALLER THAN NO. 2.
14. COORDINATE WITH POWER AUTHORITY TO LOCATE ELECTRICAL PANEL.

ELECTRICAL LEGEND

	120V DUPLEX RECEPTACLE
	120V DUPLEX RECEPTACLE UNDER COUNTER
	120V DUPLEX RECEPTACLE ABOVE COUNTER
	120V DUPLEX RECEPTACLE WATER PROOF
	120V DUPLEX RECEPTACLE GROUND FAULT PROTECTED
	120V DUPLEX RECEPTACLE FLOOR MOUNTED
	120V DUPLEX RECEPTACLE CEILING MOUNTED
	120V DEDICATED CIRCUIT
	120V COUNTERTOP POPUP GROUND FAULT PROTECTED RECEPTACLE
	120V SWITCHED RECEPTACLE
	120V 4-PLEX RECEPTACLE
	240V RECEPTACLE
	PHONE JACK
	COAX JACK
	COMBO PHONE/COAX JACK
	RECESSED CEILING LIGHT FIXTURE
	CEILING MOUNTED LIGHT FIXTURE
	WALL MOUNTED LIGHT FIXTURE
	SECURITY/FLOOD LIGHT
	PENDANT LIGHT FIXTURE
	CEILING MOUNTED CHANDELIER
	WALL SCONCE
	LED UNDER CABINET LED LIGHT
	WALL MOUNTED LIGHT BAR
	CEILING MOUNTED FLUORESCENT FIXTURE
	CEILING MOUNTED LIGHT FIXTURE WITH FAN
	SWITCH
	THREE-WAY SWITCH
	GARAGE DOOR PUSH BUTTON
	DOOR BELL
	SMOKE DETECTOR - INTERCONNECTED AND HARD-WIRED WITH BATTERY BACKUP
	SMOKE DETECTOR/CO DETECTOR
	EXHAUST FAN
	EXHAUST FAN/LIGHT
	THERMOSTAT
	CEILING MOUNTED SPEAKER
	DOOR BELL CHIME